
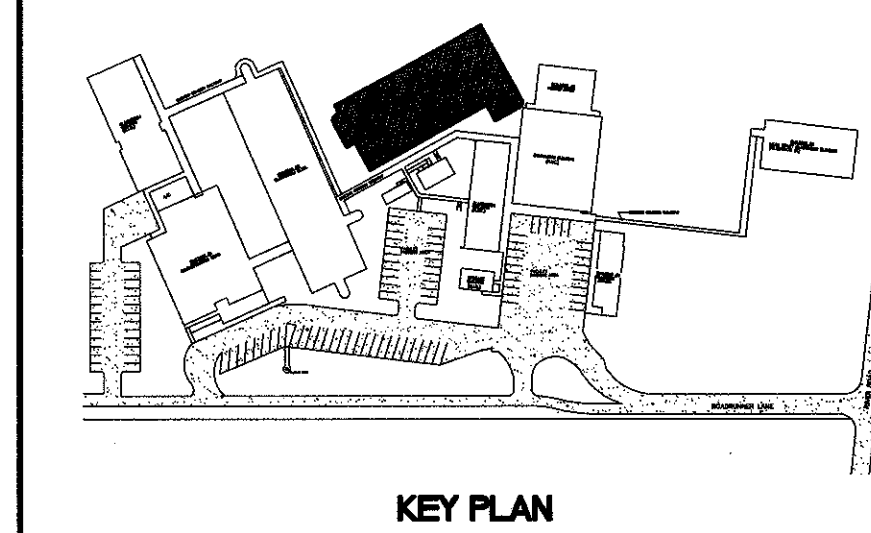


**GENERAL NOTES**

1. FOR PLUMBING VENT STACK LOCATION. SEE MECHANICAL DRAWINGS.
2. FOR ROOF VENT LOCATIONS. SEE MECHANICAL DRAWINGS.

**SPECIFIC NOTES**

- 1 BERRIDGE ZEE LOCK PANEL
- 2 BERRIDGE RIDGE CAP
- 3 8" GUTTER
- 4 DOWNSPOUT

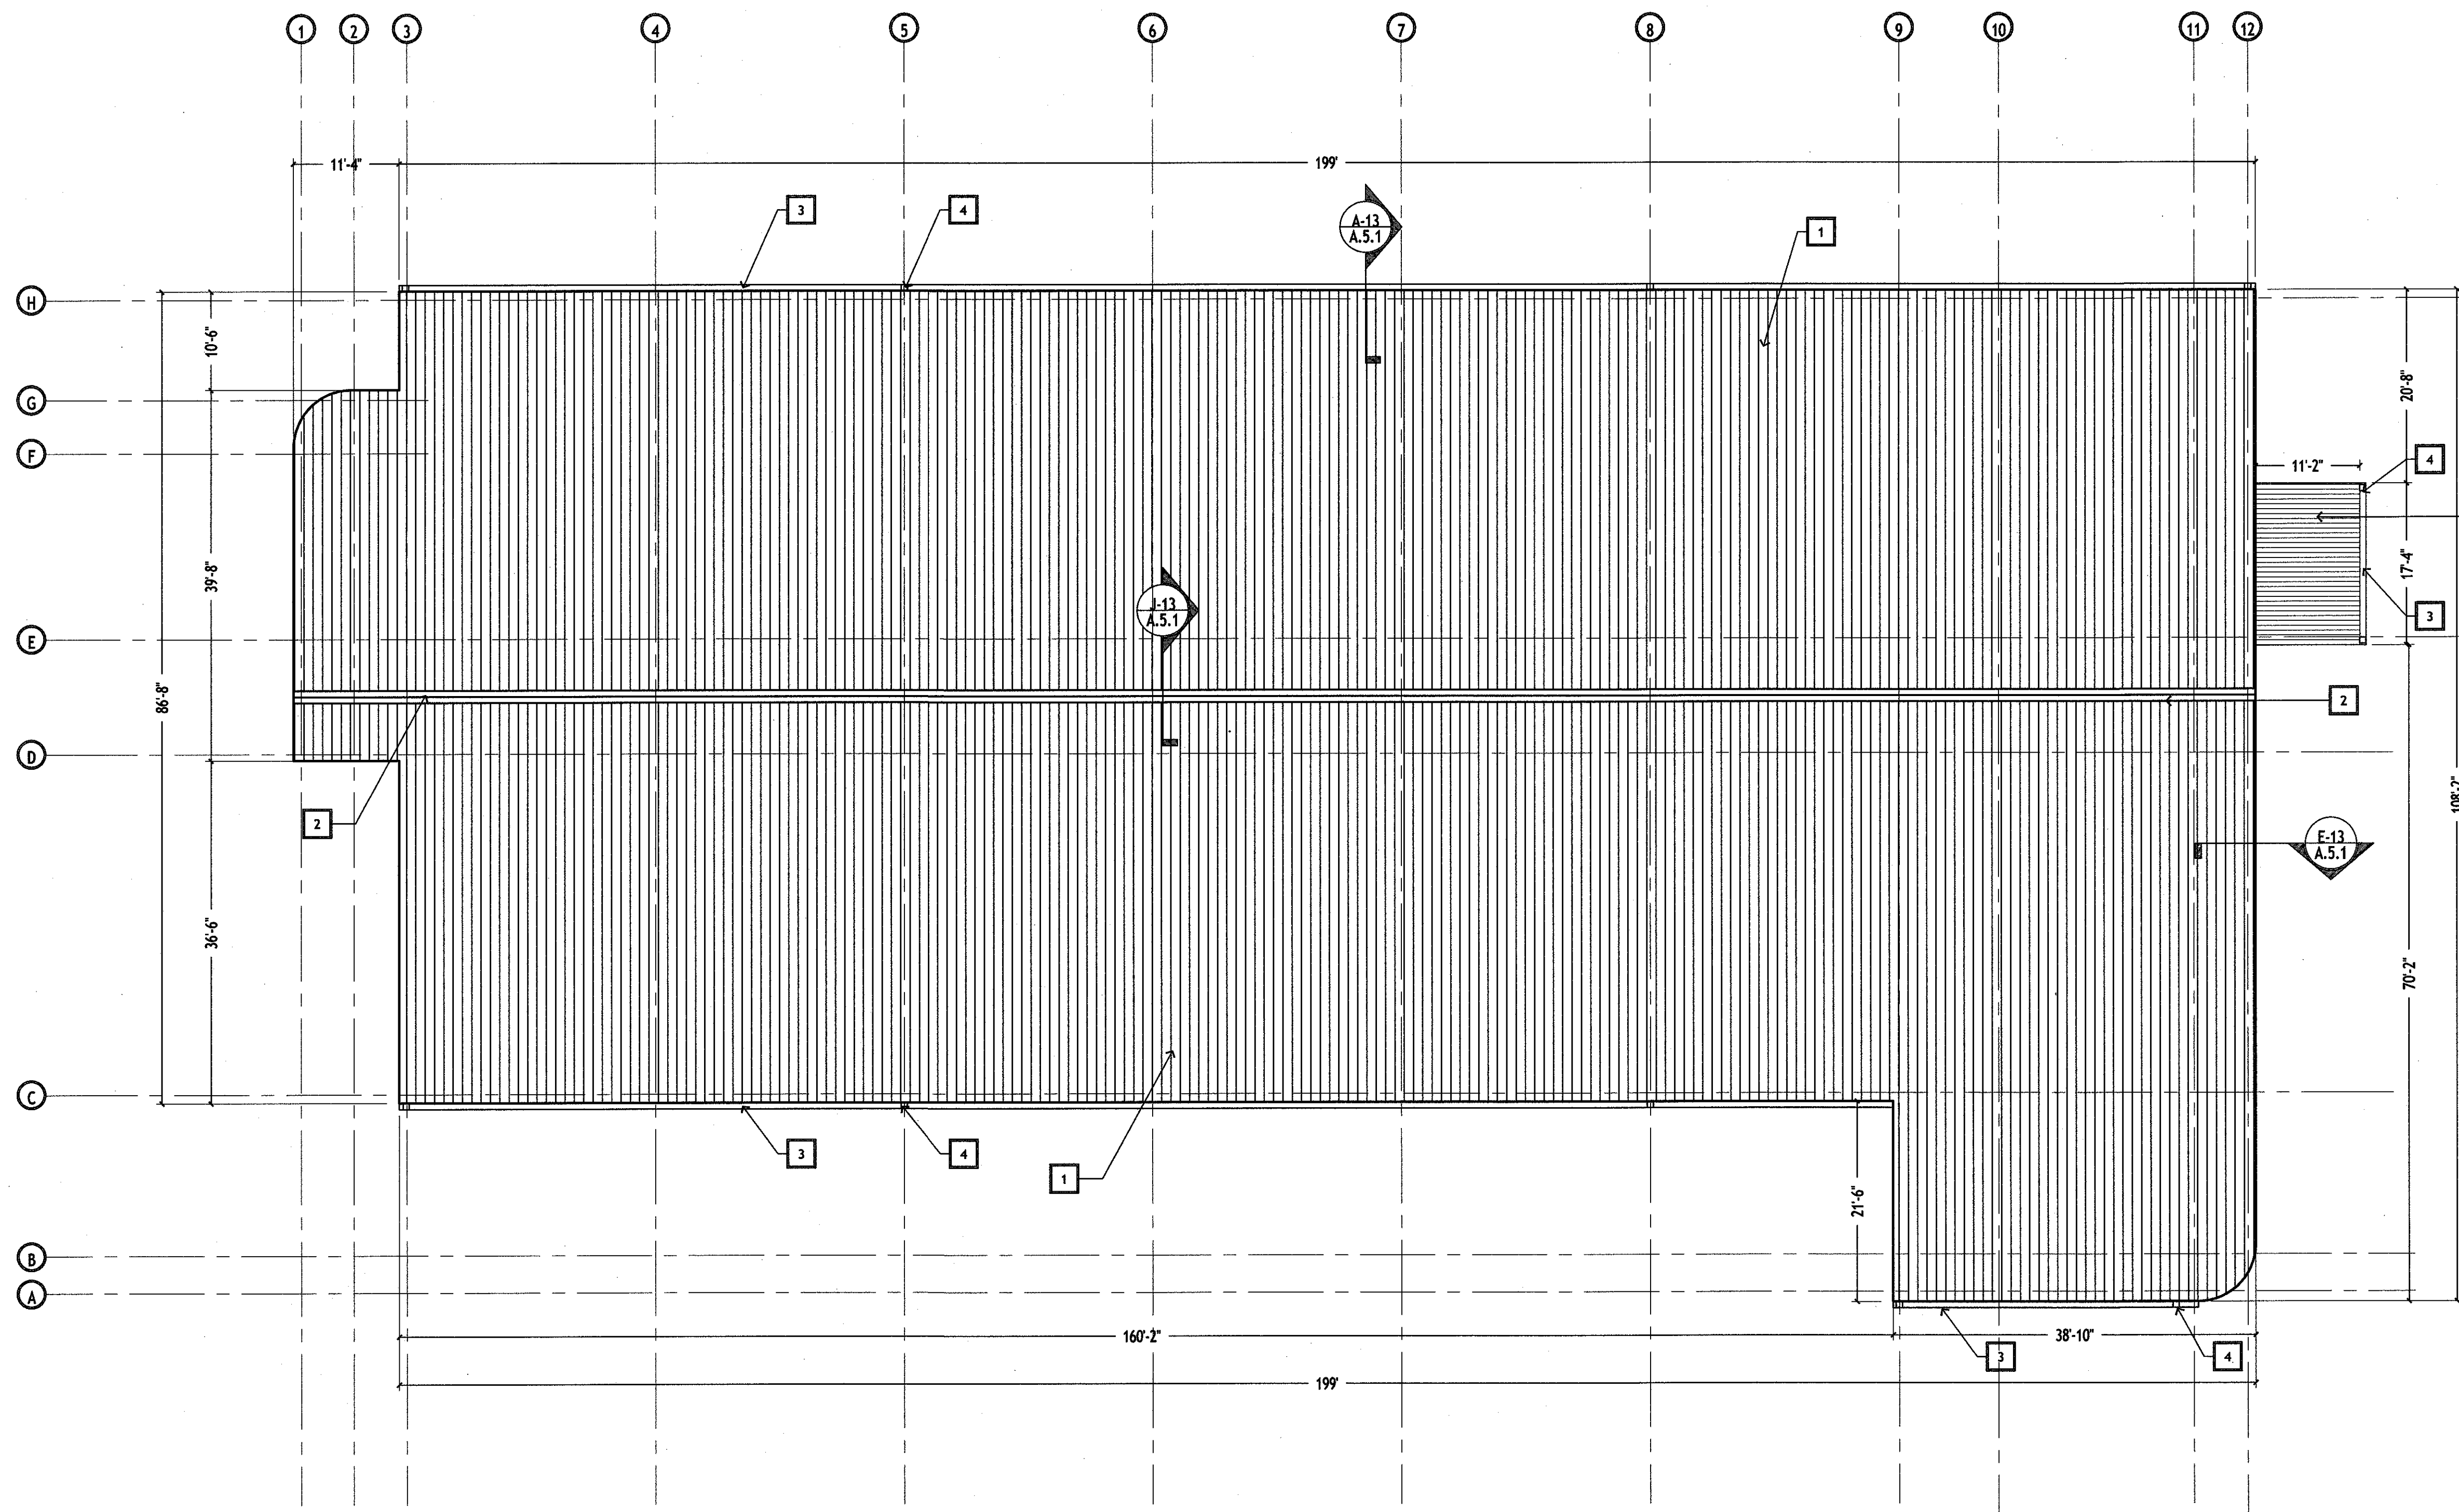

**MURRAY ARCHITECTS**  
 1331 Armond Center Court  
 Metairie, LA 70007  
 (504) 885-7747  
 Fax (504) 725-0182

no.	revisions	date
1		
2		
3		
4		
5		
6		

**HARRY HURST MIDDLE SCHOOL  
 WING ADDITION**  
 170 Roadrunner Lane, Destrehan, Louisiana 70047

ROOF PLAN

		drawing number 1007 project number 1007 date 6.14.2010 phase CD	<b>A.5.0</b>
--	--	--	--------------

ALL DIMENSIONS ARE UNLESS OTHERWISE SPECIFIED IN FEET AND INCHES. DIMENSIONS SHALL BE TO FACE UNLESS OTHERWISE SPECIFIED. ALL RIGHTS ARE RESERVED TO MURRAY ARCHITECTS.

**A-1**  
 ROOF PLAN  
 3/32"=1'-0"