


SPECIFIC NOTES:

- ① ROUTE CIRCUITING TO PANEL THROUGH LIGHTING RELAY PANEL. SEE 1/E4.01 FOR ADDITIONAL INFORMATION.
- ② LOW VOLTAGE ROOM LIGHTING CONTROL SWITCH. SEE DETAIL 1/E4.01 FOR ADDITIONAL INFORMATION.

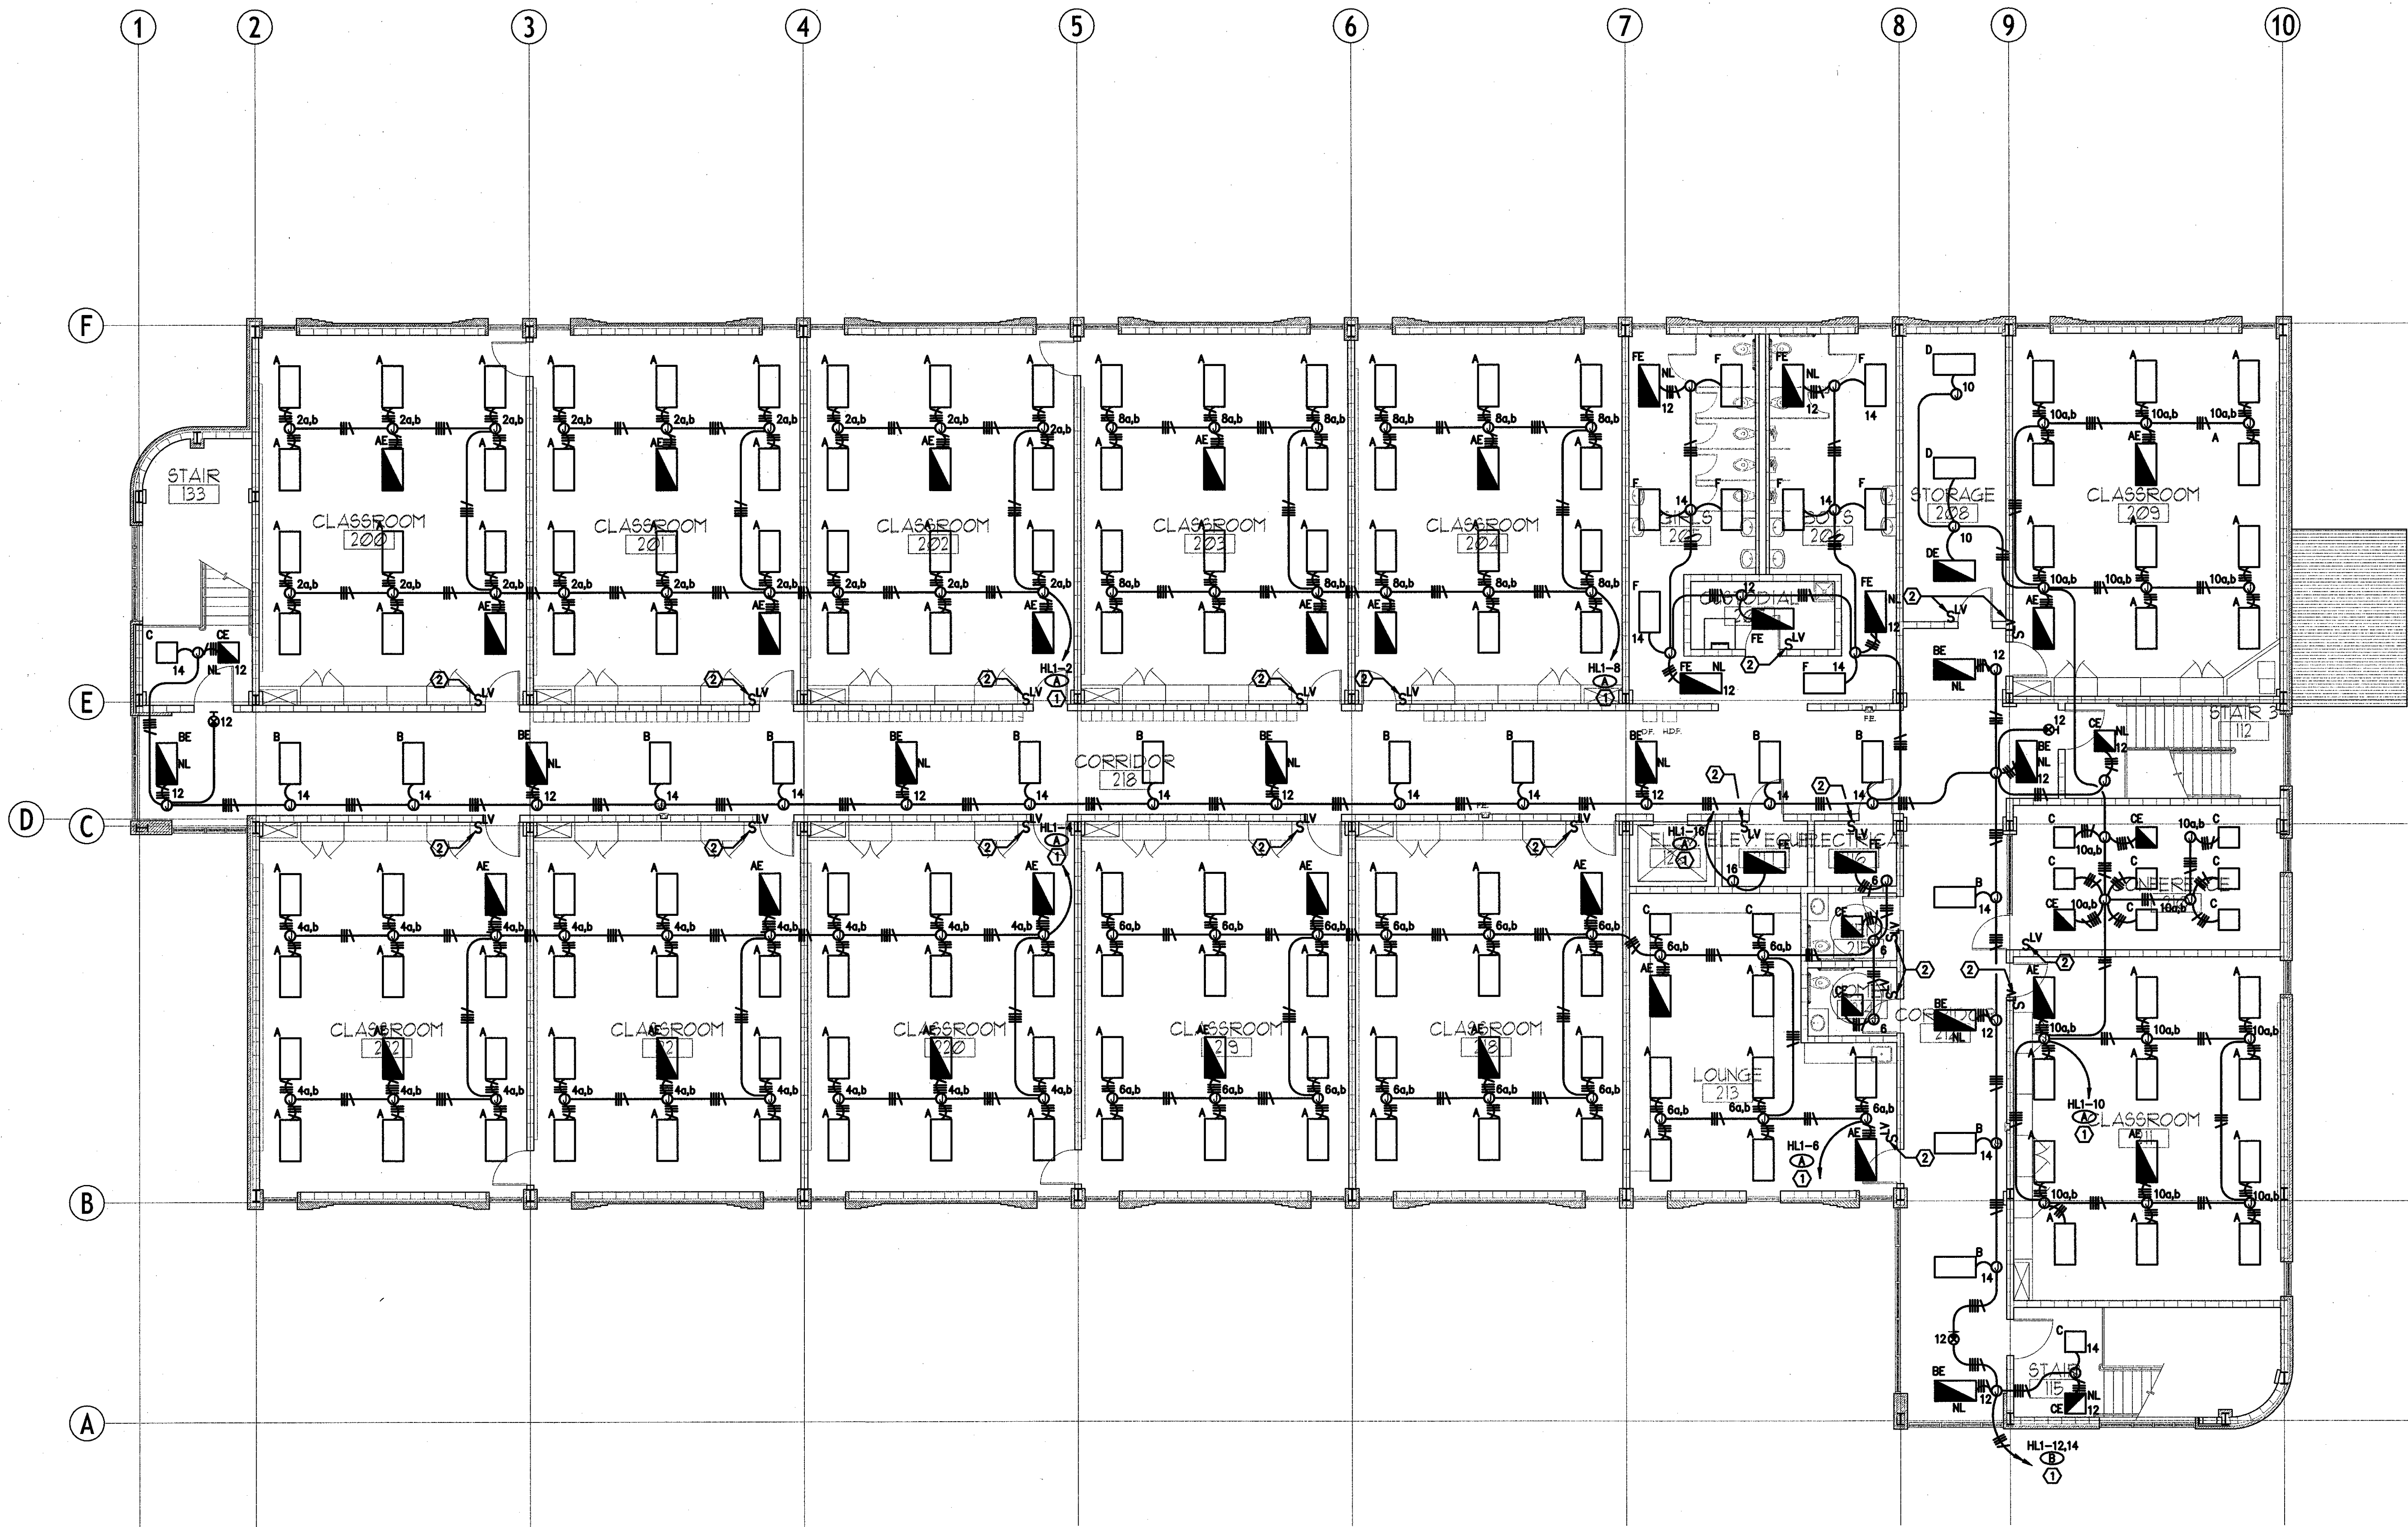

JBA Consulting Engineers, Inc
JBA New Orleans
3525 N Causeway Blvd
Suite 500
Metairie, LA 70002
p 504.830.0139

no.	revisions	date
1		
2		
3		
4		
5		
6		

**HARRY HURST MIDDLE SCHOOL
WING ADDITION**

1 Roadrunner Lane, Destrehan, Louisiana 70047

SECOND FLOOR LIGHTING PLAN

		drawing number 10.0123
	ALVIN L. PHELPS, JR. License No. 30202 PROFESSIONAL ENGINEER	date 06.14.2010

E1.01 SECOND FLOOR LIGHTING PLAN

1/8" = 1'-0"



THESE DOCUMENTS ARE PROTECTED BY UNITED STATES COPYRIGHT LAW. THEY HAVE BEEN PREPARED SPECIFICALLY FOR THE CLIENT AND ARE NOT TO BE REPRODUCED OR TRANSMITTED IN ANY FORM OR BY ANY MEANS, ELECTRONIC OR MECHANICAL, INCLUDING PHOTOCOPYING, RECORDING, OR BY ANY INFORMATION STORAGE AND RETRIEVAL SYSTEM, WITHOUT THE EXPRESS WRITTEN APPROVAL AND PARTICIPATION OF MURRAY ARCHITECTS. REPRODUCTION OF THESE DOCUMENTS WITHOUT THE EXPRESS WRITTEN APPROVAL OF MURRAY ARCHITECTS IS STRICTLY PROHIBITED. ALL RIGHTS ARE RESERVED TO MURRAY ARCHITECTS.