


NOTES

- ① 16/16 EA DUCT UP.
- ② 8/8 EA DUCT UP.
- ③ 12/12 SA DUCT FROM ABOVE.
- ④ 14/14 RA DUCT UP.
- ⑤ 12/10 SA DUCT FROM ABOVE.
- ⑥ 16/14 RA DUCT UP.
- ⑦ 16/14 SA DUCT FROM ABOVE.
- ⑧ 16/16 SA DUCT FROM ABOVE.
- ⑨ 14/16 RA DUCT UP.
- ⑩ PROVIDE 2 SQUARE FOOT FREE AREA EXHAUST LOUVER. PROVIDE 12" DEEP PLENUM BEHIND LOUVER. COORDINATE WITH ARCHITECTURAL DRAWINGS.
- ⑪ DDC PANEL LOCATED IN IT ROOM.
- ⑫ 16/16 EA DUCT UP FROM HOOD. TRANSITION FROM FULL SIZE OPENING OF FUME HOOD EXHAUST.
- ⑬ CONTRACTOR TO MOUNT PLAQUARD ON FUME HOOD NOTING THAT IT SHALL ONLY BE USED TO EXHAUST HOUSEHOLD CHEMICALS SUCH AS VINEGAR, AMMONIA, ETC.
- ⑭ 20/14 RA DUCT UP.
- ⑮ TERMINAL UNIT TO BE MOUNTED 24" MAXIMUM ABOVE CEILING.
- ⑯ PROVIDE 3 SQUARE FOOT FREE AREA EXHAUST LOUVER. PROVIDE 12" DEEP PLENUM BEHIND LOUVER. COORDINATE WITH ARCHITECTURAL DRAWINGS.
- ⑰ PROVIDE 2.5 SQUARE FOOT FREE AREA EXHAUST LOUVER. PROVIDE 12" DEEP PLENUM BEHIND LOUVER. COORDINATE WITH ARCHITECTURAL DRAWINGS.
- ⑱ PROVIDE 2.5 SQUARE FOOT FREE AREA MAKE UP AIR LOUVER IN DOOR. COORDINATE WITH ARCHITECTURAL DRAWINGS.
- ⑲ SENSOR TO SEND ALARM SIGNAL TO DDC PANEL WHEN ROOM IS ABOVE 108'.
- ⑳ 24/24 RA DUCT UP.

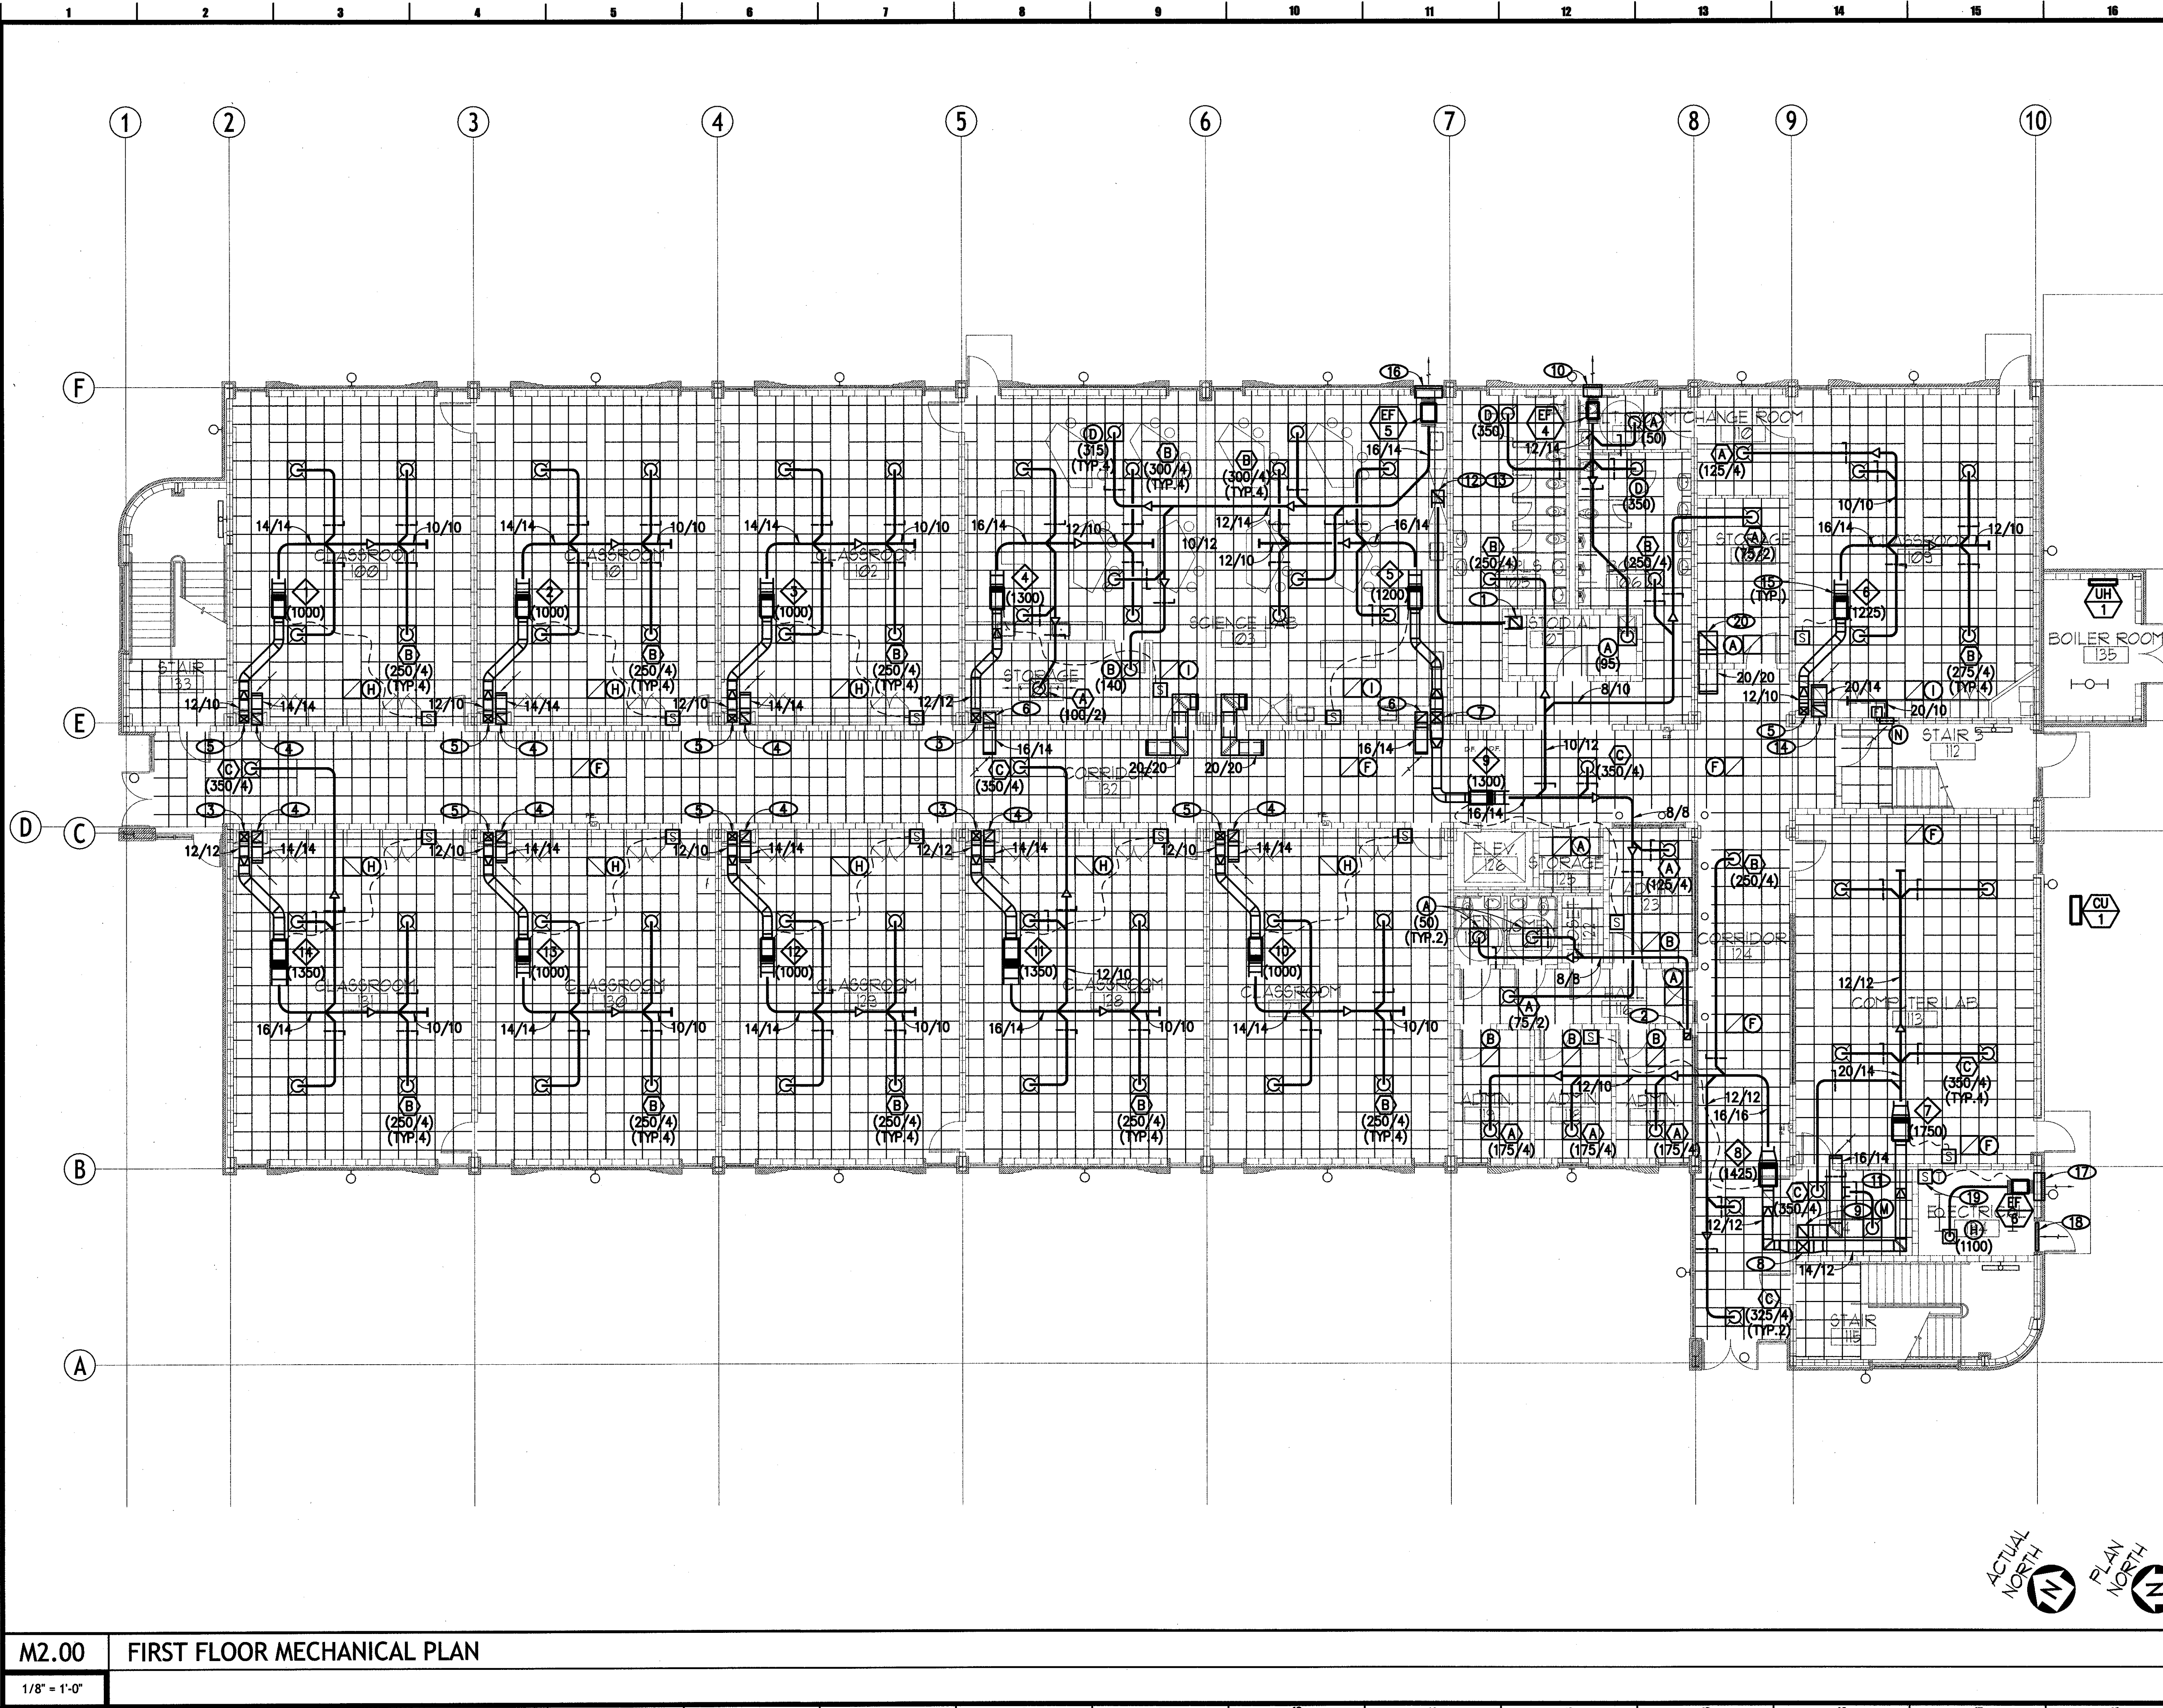

MURRAY ARCHITECTS
 131 omnium center court
 destrehan, la 70047
 (504) 885-1250

jba Consulting Engineers, Inc
 JBA New Orleans
 3525 N Causeway Blvd
 Suite 500
 Metairie, LA 70002
 p 504.830.0139

no.	revisions	date
1		
2		
3		
4		
5		
6		

HARRY HURST MIDDLE SCHOOL WING ADDITION
 1 Roadrunner Lane, Destrehan, Louisiana 70047
 FIRST FLOOR MECHANICAL PLAN

MURRAY ARCHITECTS
 ROYAL CHARLES EDWARDS
 License No. 95976
 PROFESSIONAL ENGINEER

drawing number
 project number 10.0123
 date 06.14.2010
 phase CD

THESE DOCUMENTS ARE PROTECTED BY UNITED STATES COPYRIGHT LAW. THEY HAVE BEEN PREPARED SPECIFICALLY FOR THE CLIENT AND ARE NOT TO BE REPRODUCED OR TRANSMITTED IN ANY FORM OR BY ANY MEANS, ELECTRONIC OR MECHANICAL, INCLUDING PHOTOCOPYING, RECORDING, OR BY ANY INFORMATION STORAGE AND RETRIEVAL SYSTEM, WITHOUT THE EXPRESS WRITTEN APPROVAL AND PARTICIPATION OF MURRAY ARCHITECTS. REPRODUCTION OF THESE DOCUMENTS MUST BE AUTHORIZED BY THE ARCHITECT. ALL RIGHTS ARE RESERVED TO MURRAY ARCHITECTS.

M2.00 FIRST FLOOR MECHANICAL PLAN

1/8" = 1'-0"

M2.00

6-20-10