


**LEGEND**

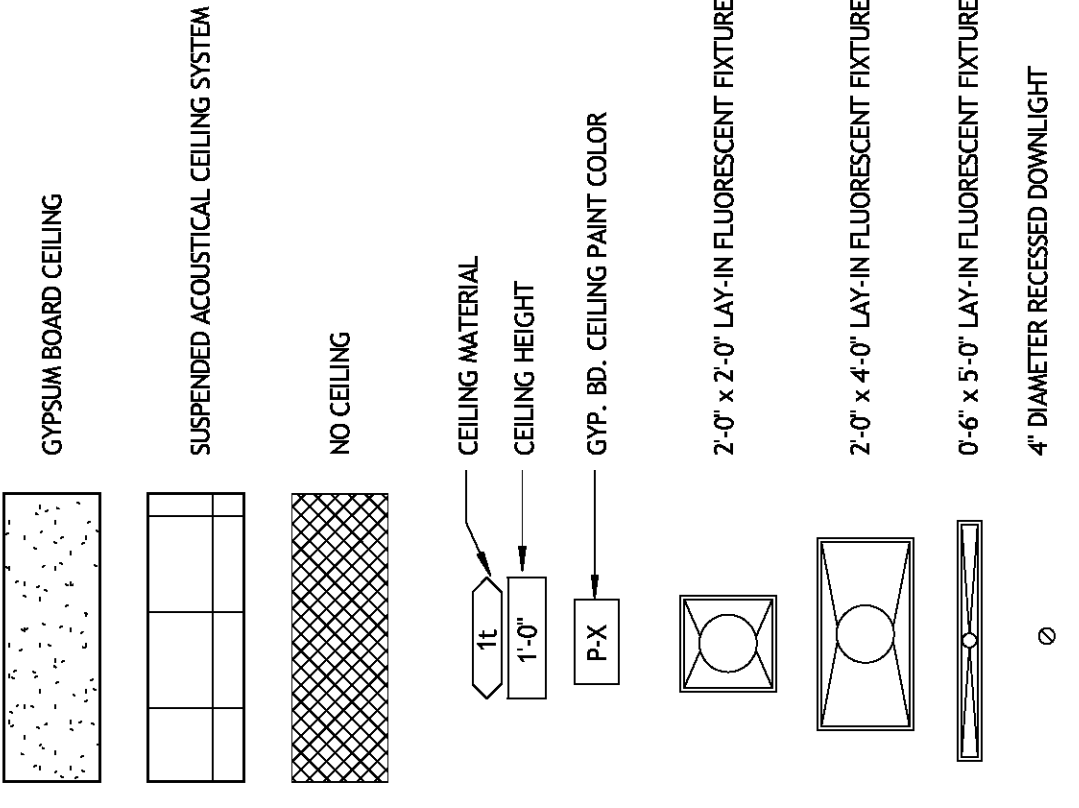


**CEILING SCHEDULE**

**ACTL1**  
 MANUFACTURER: ARMSTRONG  
 STYLE: TECHTRONICS  
 PANEL SIZE: 30" X 30" X 3/4"  
 TECH PANEL: ULTIMA 1005  
 EDGE: 9/16" BEVELED REGULAR  
 GRID: INTERLUDE  
 FINISH: WHITE  
 SIZE: 9'x9'

**ACTL2**  
 MANUFACTURER: ARMSTRONG  
 PANEL: DUNE  
 PANEL SIZE: 24" X 24"  
 EDGE: 9/16" BEVELED REGULAR  
 GRID: INTERLUDE XL  
 FINISH: WHITE  
 SIZE: 9'x9'

**GWB**  
 GYPSUM BOARD CEILING  
 NOTE: SEE FINISH SCHEDULE FOR PAINT COLOR

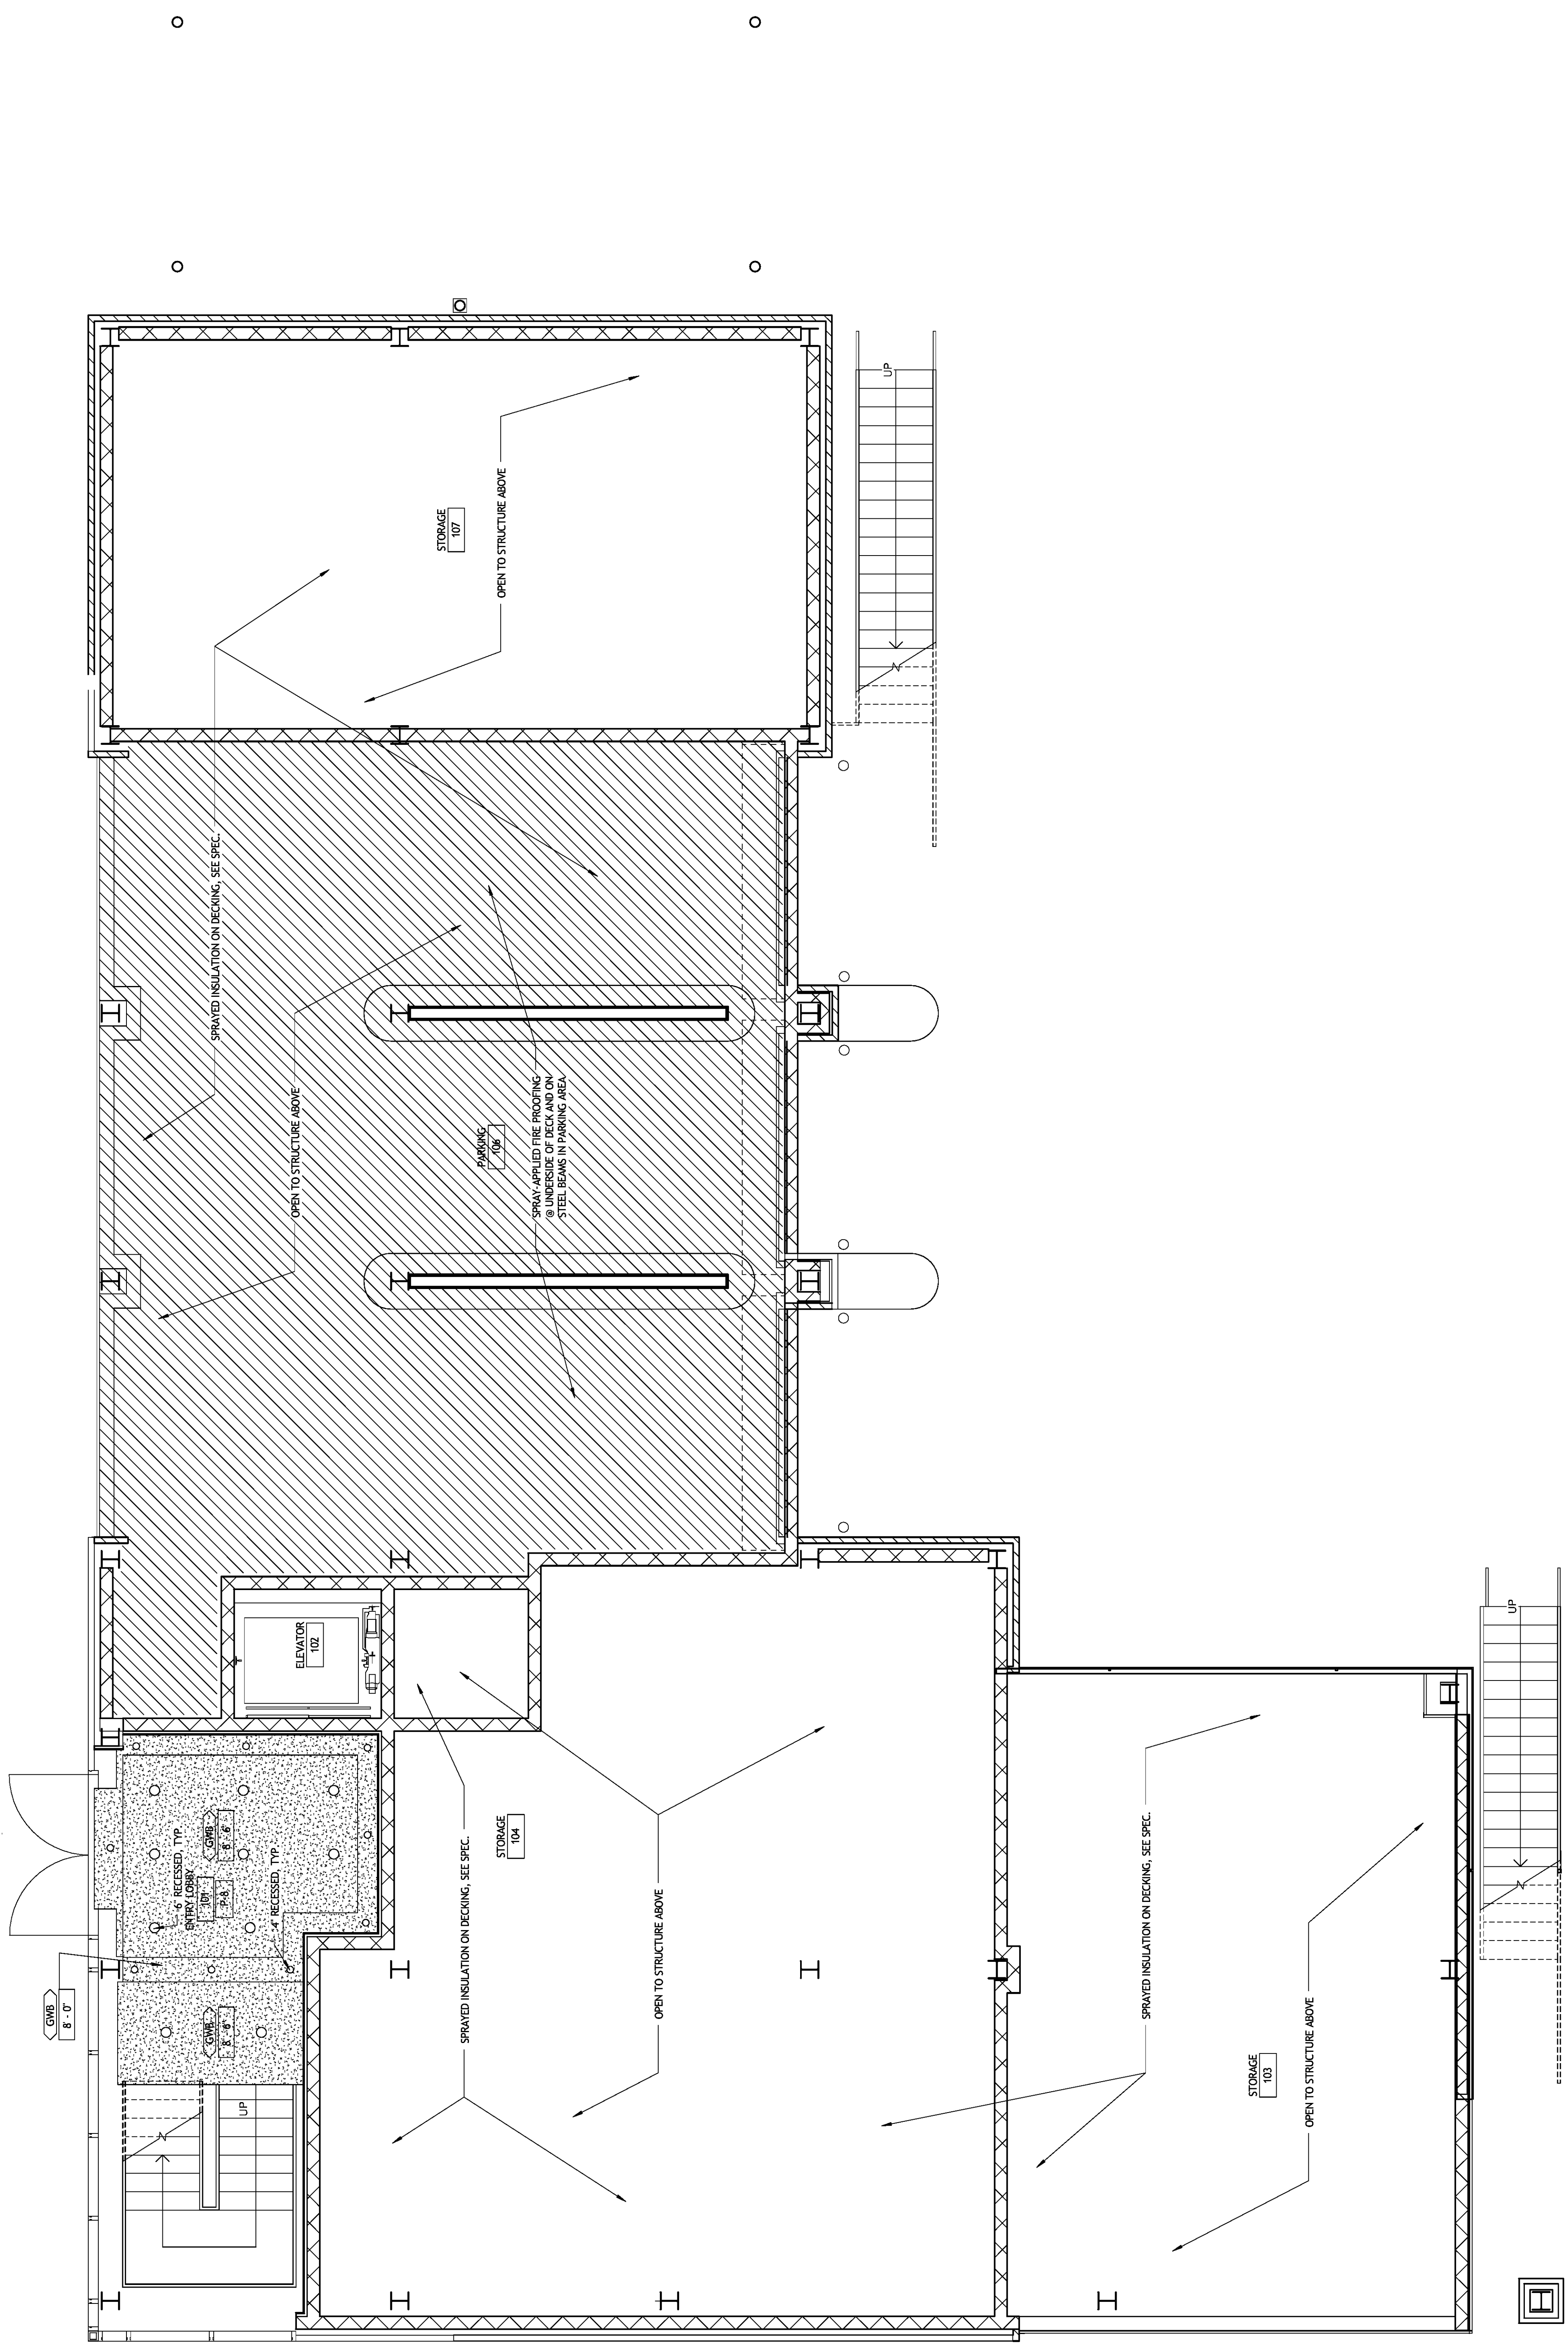

**SIZELER THOMPSON BROWN ARCHITECTS**  
**PROJECT DESIGN GROUP**  
 3001 LAFAYETTE STREET, SUITE 200  
 NEW ORLEANS, LOUISIANA 70130  
 THOMAS BROWN ARCHITECTS  
 (504) 523-6472 FAX (504) 529-1181

No.	Revisions	Description	Date

**JEFFERSON PARISH SHERIFFS OFFICE**  
**FOURTH DISTRICT STATION**  
 METAIRIE, LOUISIANA 70003

GROUND LEVEL REFLECTED CEILING PLAN

File name	Sub-station.rvt	drawing number
Project number	51122.03	
Date	02-25-10	
Phase	CD	

1 GROUND LEVEL REFLECTED CEILING PLAN  
 A601 1/4" = 1'-0"