

HUSEMAN & Associates
 MECHANICAL ELECTRICAL PLUMBING FIRE PROTECTION
 Job No. 090003
 Drawn By: RM
 Designed By: RM
 Checked By: CRB

3925 N. I-10 SERVICE RD
 METairie, LA 70002
 (504) 456-3119
 (504) 456-3122

REGIONAL DESIGN GROUP, LLC
 300 LAFAYETTE STREET, SUITE 200
 NEW ORLEANS, LOUISIANA 70130
 (504) 523-6472 FAX (504) 529-1181


NO.	REVISIONS	DATE
1	REVISION	
2		
3		
4		
5		

JEFFERSON PARISH SHERIFF'S OFFICE
 4TH DISTRICT SUBSTATION
 JEFFERSON PARISH, LOUISIANA

FIRST FLOOR PLAN - PLUMBING

File name	090003P200.dwg	drawing number
Project number	51122.03	
Date	02-04-10	
Phase	CD	

P200

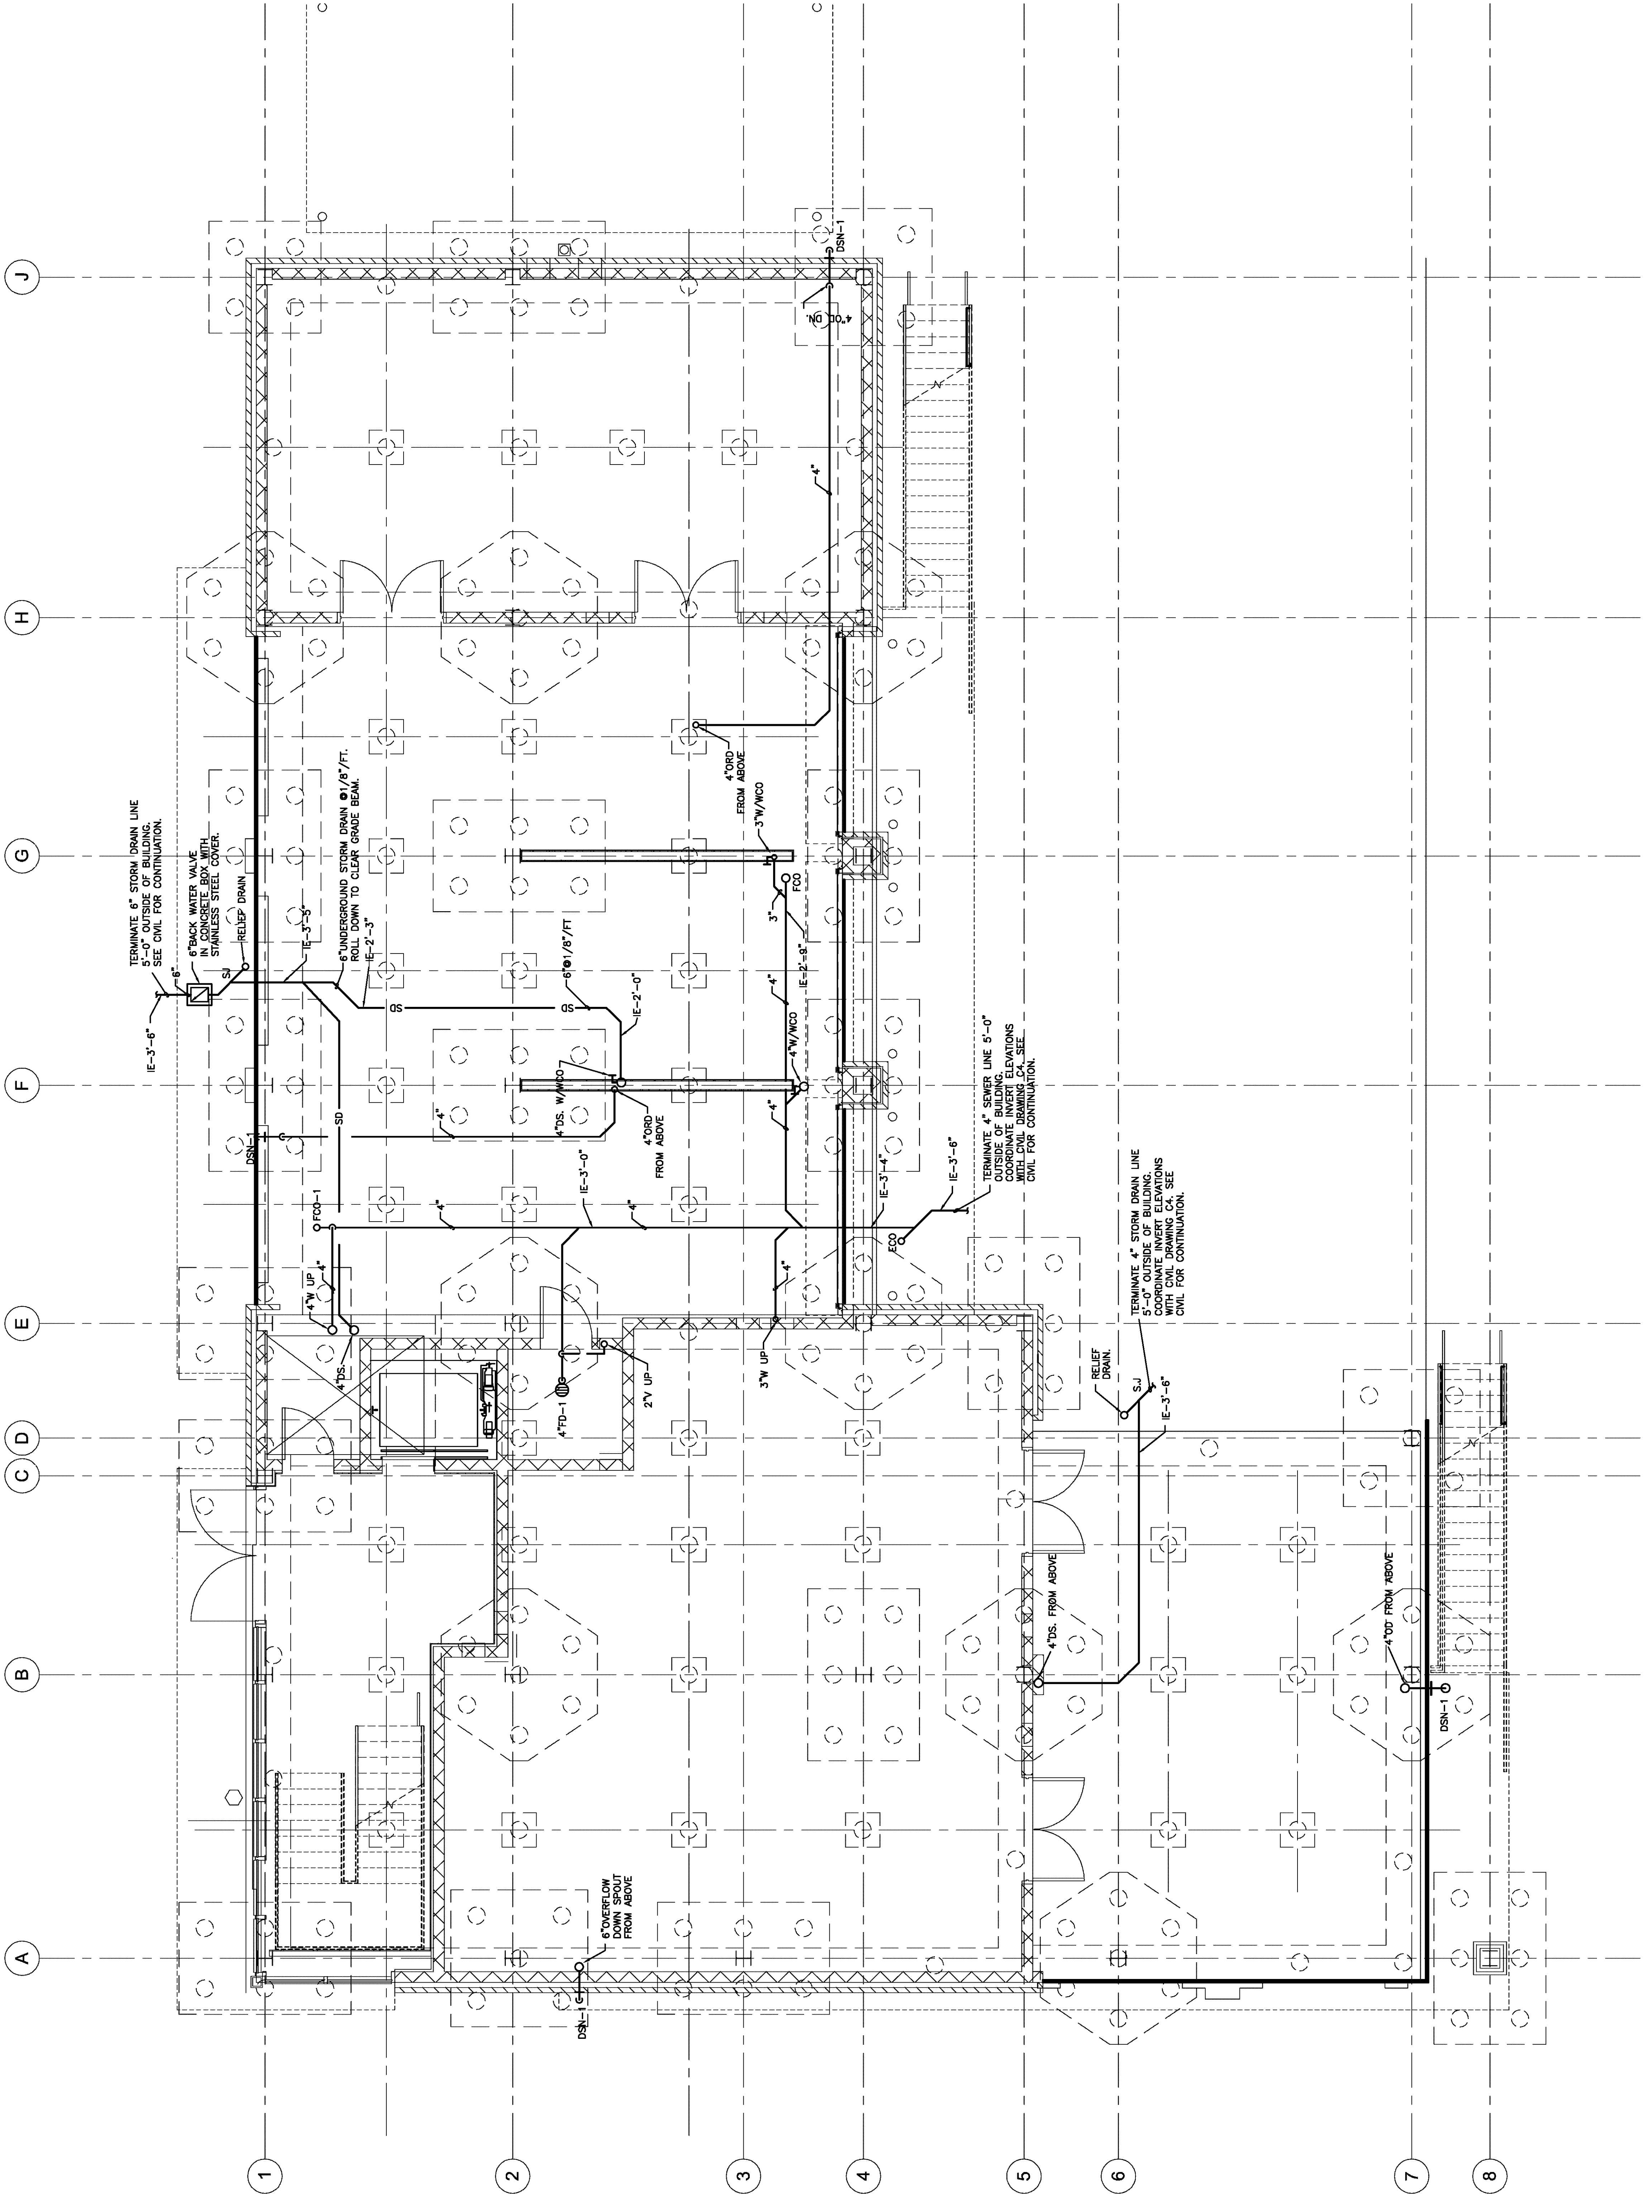

1 1ST FLOOR - PLUMBING
 1/4" = 1'-0"

ALL INVERT ELEVATIONS
 ARE TAKEN FROM FIN. SLAB.