


- NOTES:
1. REFER TO THE STRUCTURAL PLANS FOR CLEARING ALL INTERIOR AND EXTERIOR GRADE BEAMS AND FOOTINGS.
 2. REFER TO WATER RISERS FOR WATER LINES TO TRAP PRIMERS.

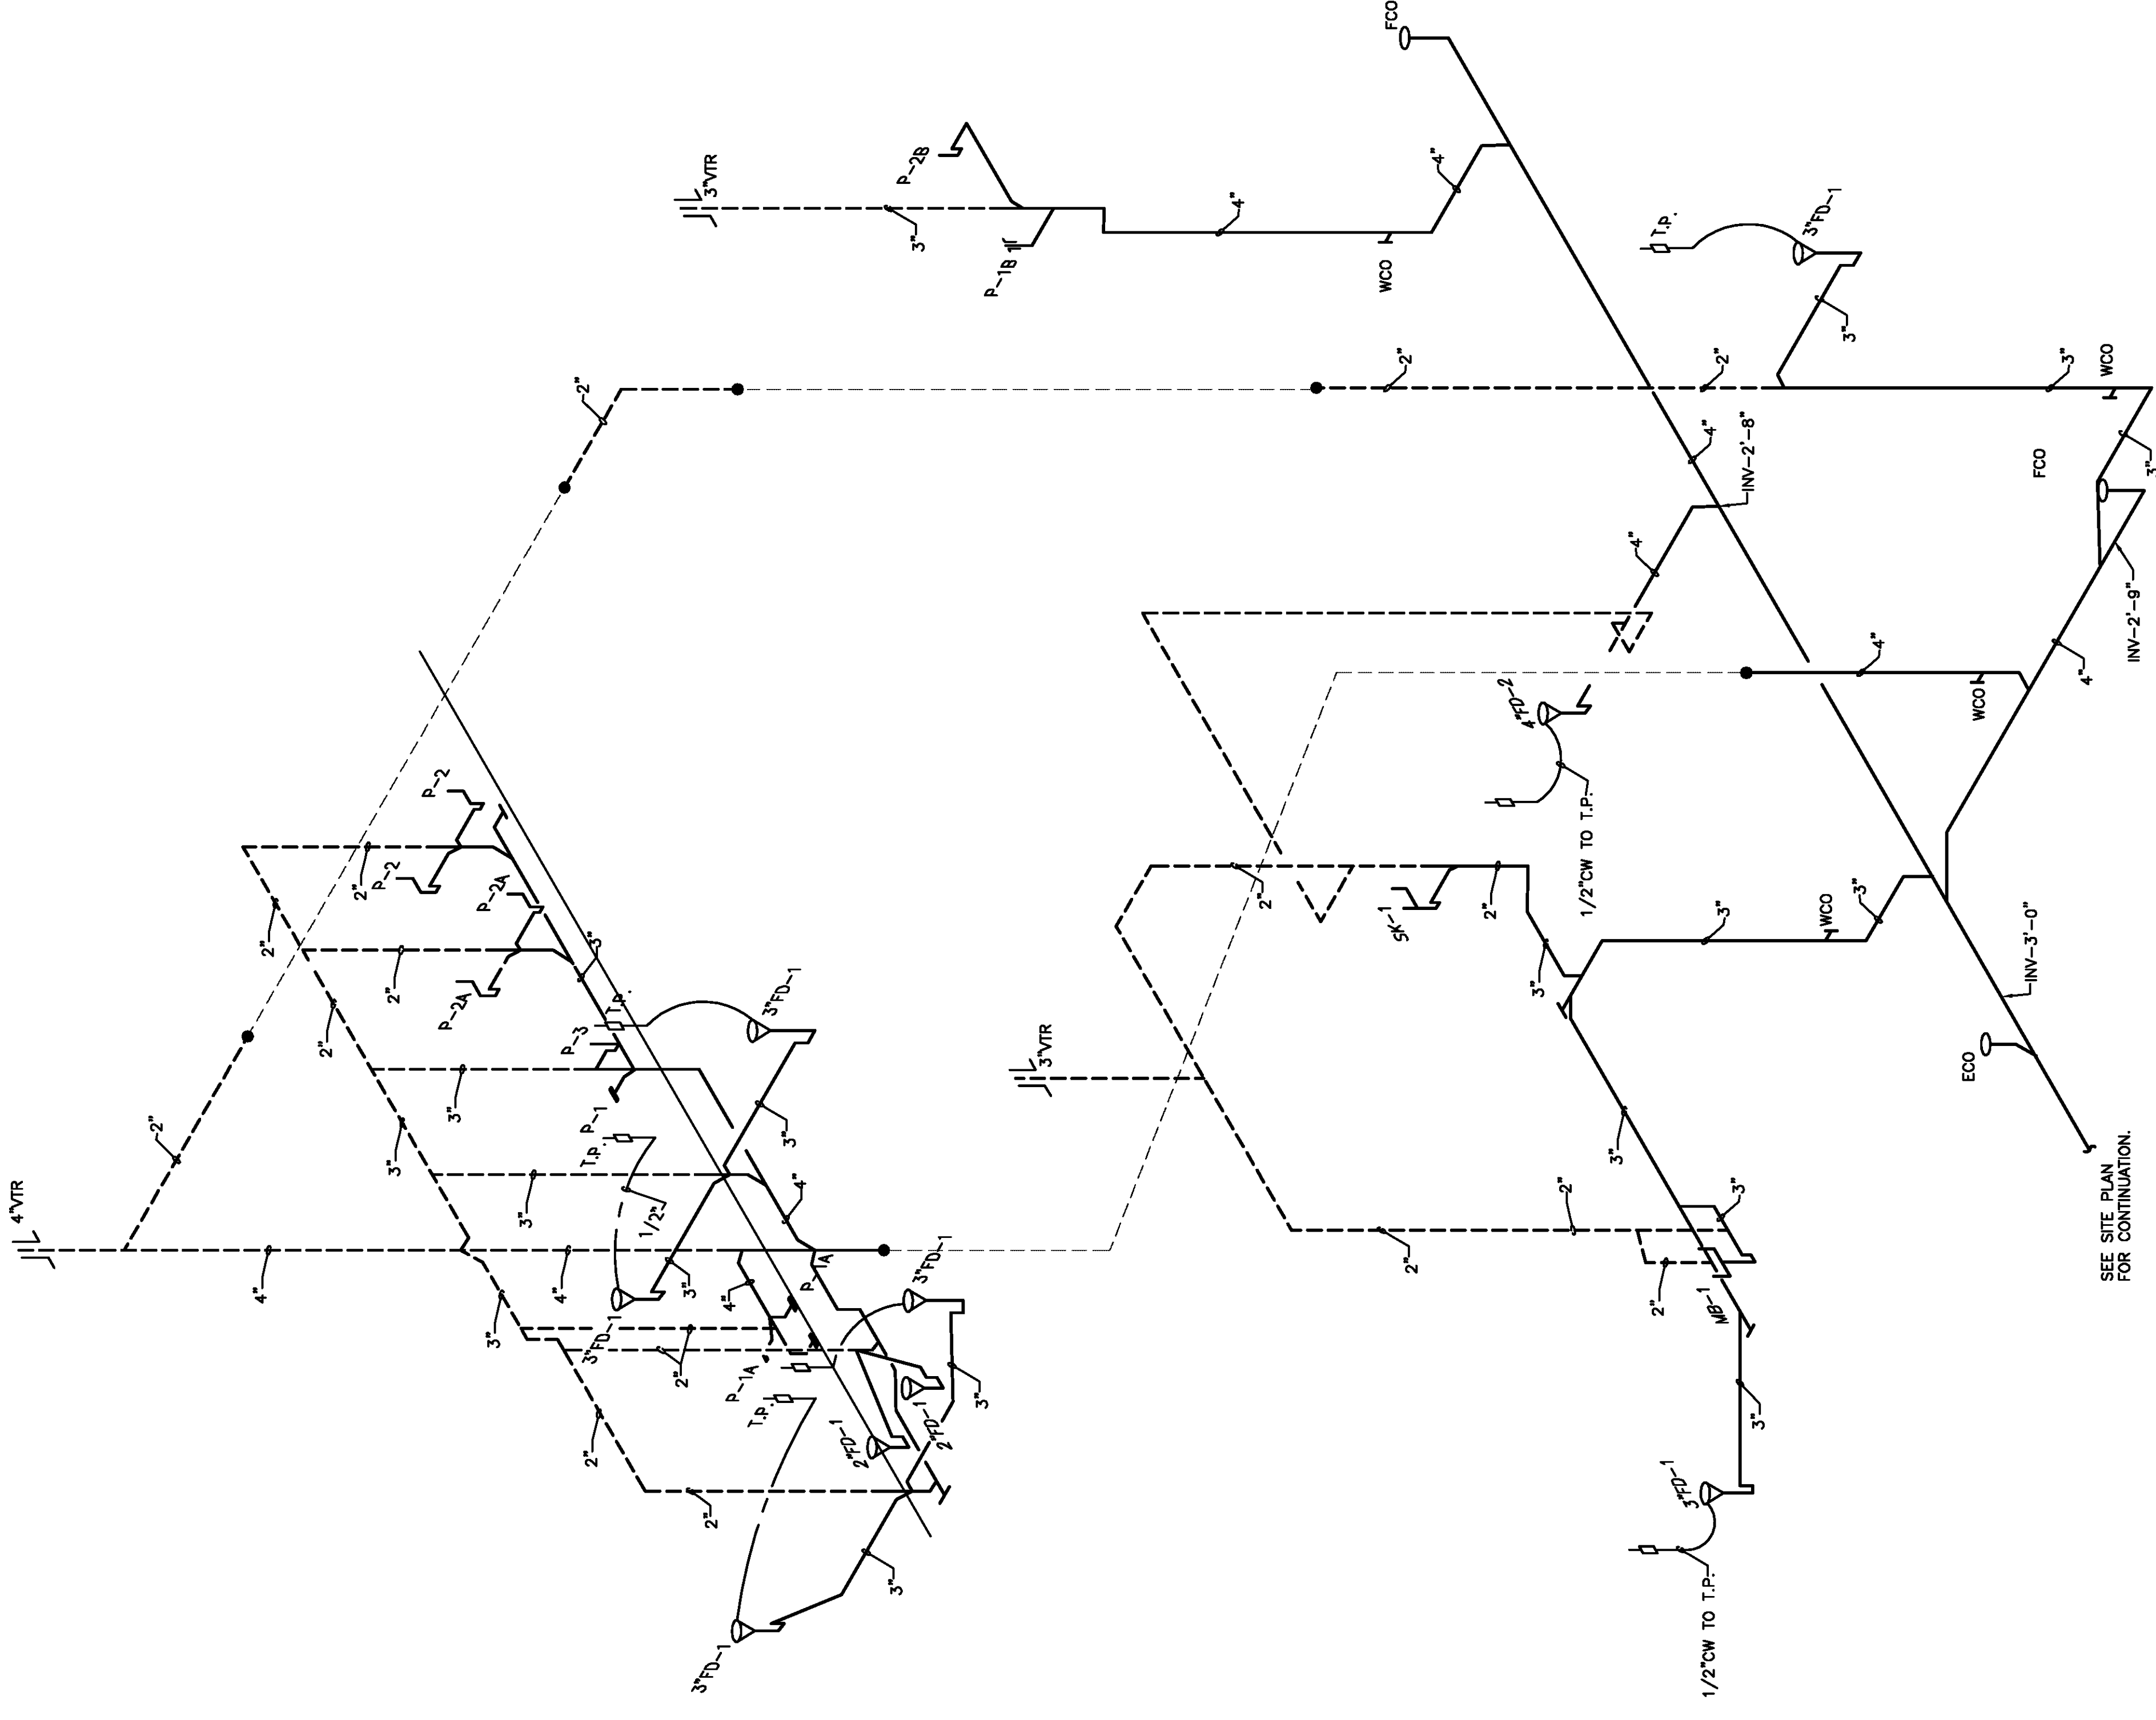

SEE SITE PLAN FOR CONTINUATION.

HUSEMAN & Associates
 MECHANICAL ELECTRICAL PLUMBING FIRE PROTECTION
 Job No. 000003
 Drawn By: RM
 Designed By: RM
 Checked By: CRB

3925 N. I-10 SERVICE RD
 METairie, LA 70002
 (504) 456-3119
 FAX (504) 456-3122

REGIONAL DESIGN GROUP, LLC
 300 LAFAYETTE STREET, SUITE 200
 NEW ORLEANS, LOUISIANA 70130
 (504) 523-6472 FAX (504) 529-1181

WHEELER
TRONSON
BROWN
 ARCHITECTS

NO.	REVISION	DATE
1		
2		
3		
4		
5		

JEFFERSON PARISH SHERIFF'S OFFICE
 4TH DISTRICT SUBSTATION
 JEFFERSON PARISH, LOUISIANA

WASTE AND VENT RISER DIAGRAMS

File name	0900603P100.dwg	drawing number
Project number	51122.03	
Date	02-04-10	
Phase	CD	

1 WASTE AND VENT RISER DIAGRAM
 P400 NTS

P400