


**LEGEND:**

- EXISTING GRADES
- EXISTING CONTOURS
- PROPOSED GRADES
- REQ'D 24"x24" DROP-INLET (BRICK)
- DRAINAGE DIRECTION
- CROWN / RIDGE
- 4" CONCRETE PAVING

**NOTES:**

1. CONTRACTOR SHALL VERIFY LOCATION AND ELEVATION OF ALL EXISTING UTILITIES PRIOR TO START OF CONSTRUCTION. SHOULD CONFLICT EXIST, CONTRACTOR SHALL CONTACT PROJECT MANAGER AND ENGINEER.
2. CONTRACTOR TO ARRANGE FOR AND PAY ALL REQUIRED FEES FOR UTILITY SERVICE CONNECTIONS.
3. ALL PROPOSED STORM SEWER PIPING IS A2000 PVC.

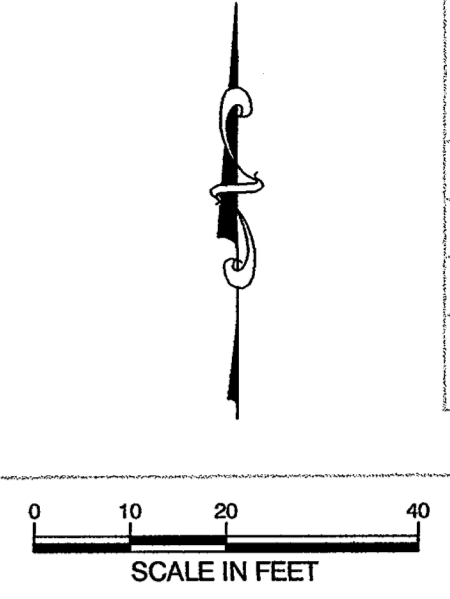


CADD FILE NAME:  
41034-PL-DRAINAGE.dwg

DESIGNED BY: SMG	DRAWN BY: TM	CHECKED BY: SMG	JOB NO. 41034
SCALE: (24x36) 1" = 20'	SCALE: (11x17) 1" = 40'	DATE: 30-JUL-10	

**NORTHLAKE CHRISTIAN SCHOOL**  
COVINGTON, LOUISIANA

**M-P BUILDING GRADING & DRAINAGE PLAN**

DATE	REVISIONS	APPROVED

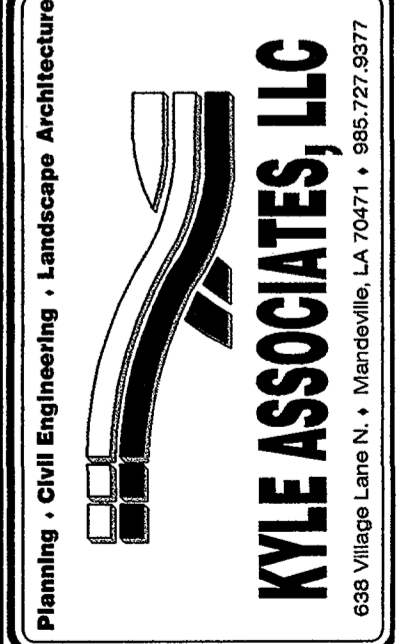

SHEET NO.  
**C3.1**

N:\03\04\034 - Northlake Christian New Pre-School\Drawings\1) Plans\Civil\MP\41034-PL-DRAINAGE.dwg, 24x36-FULL, 8/30/2010 1:47:48 PM, tmmf

