



REVISIONS

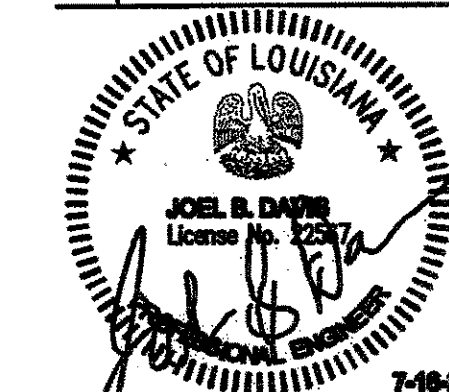

FILE	3316
DATE	07/16/10
SHEET	

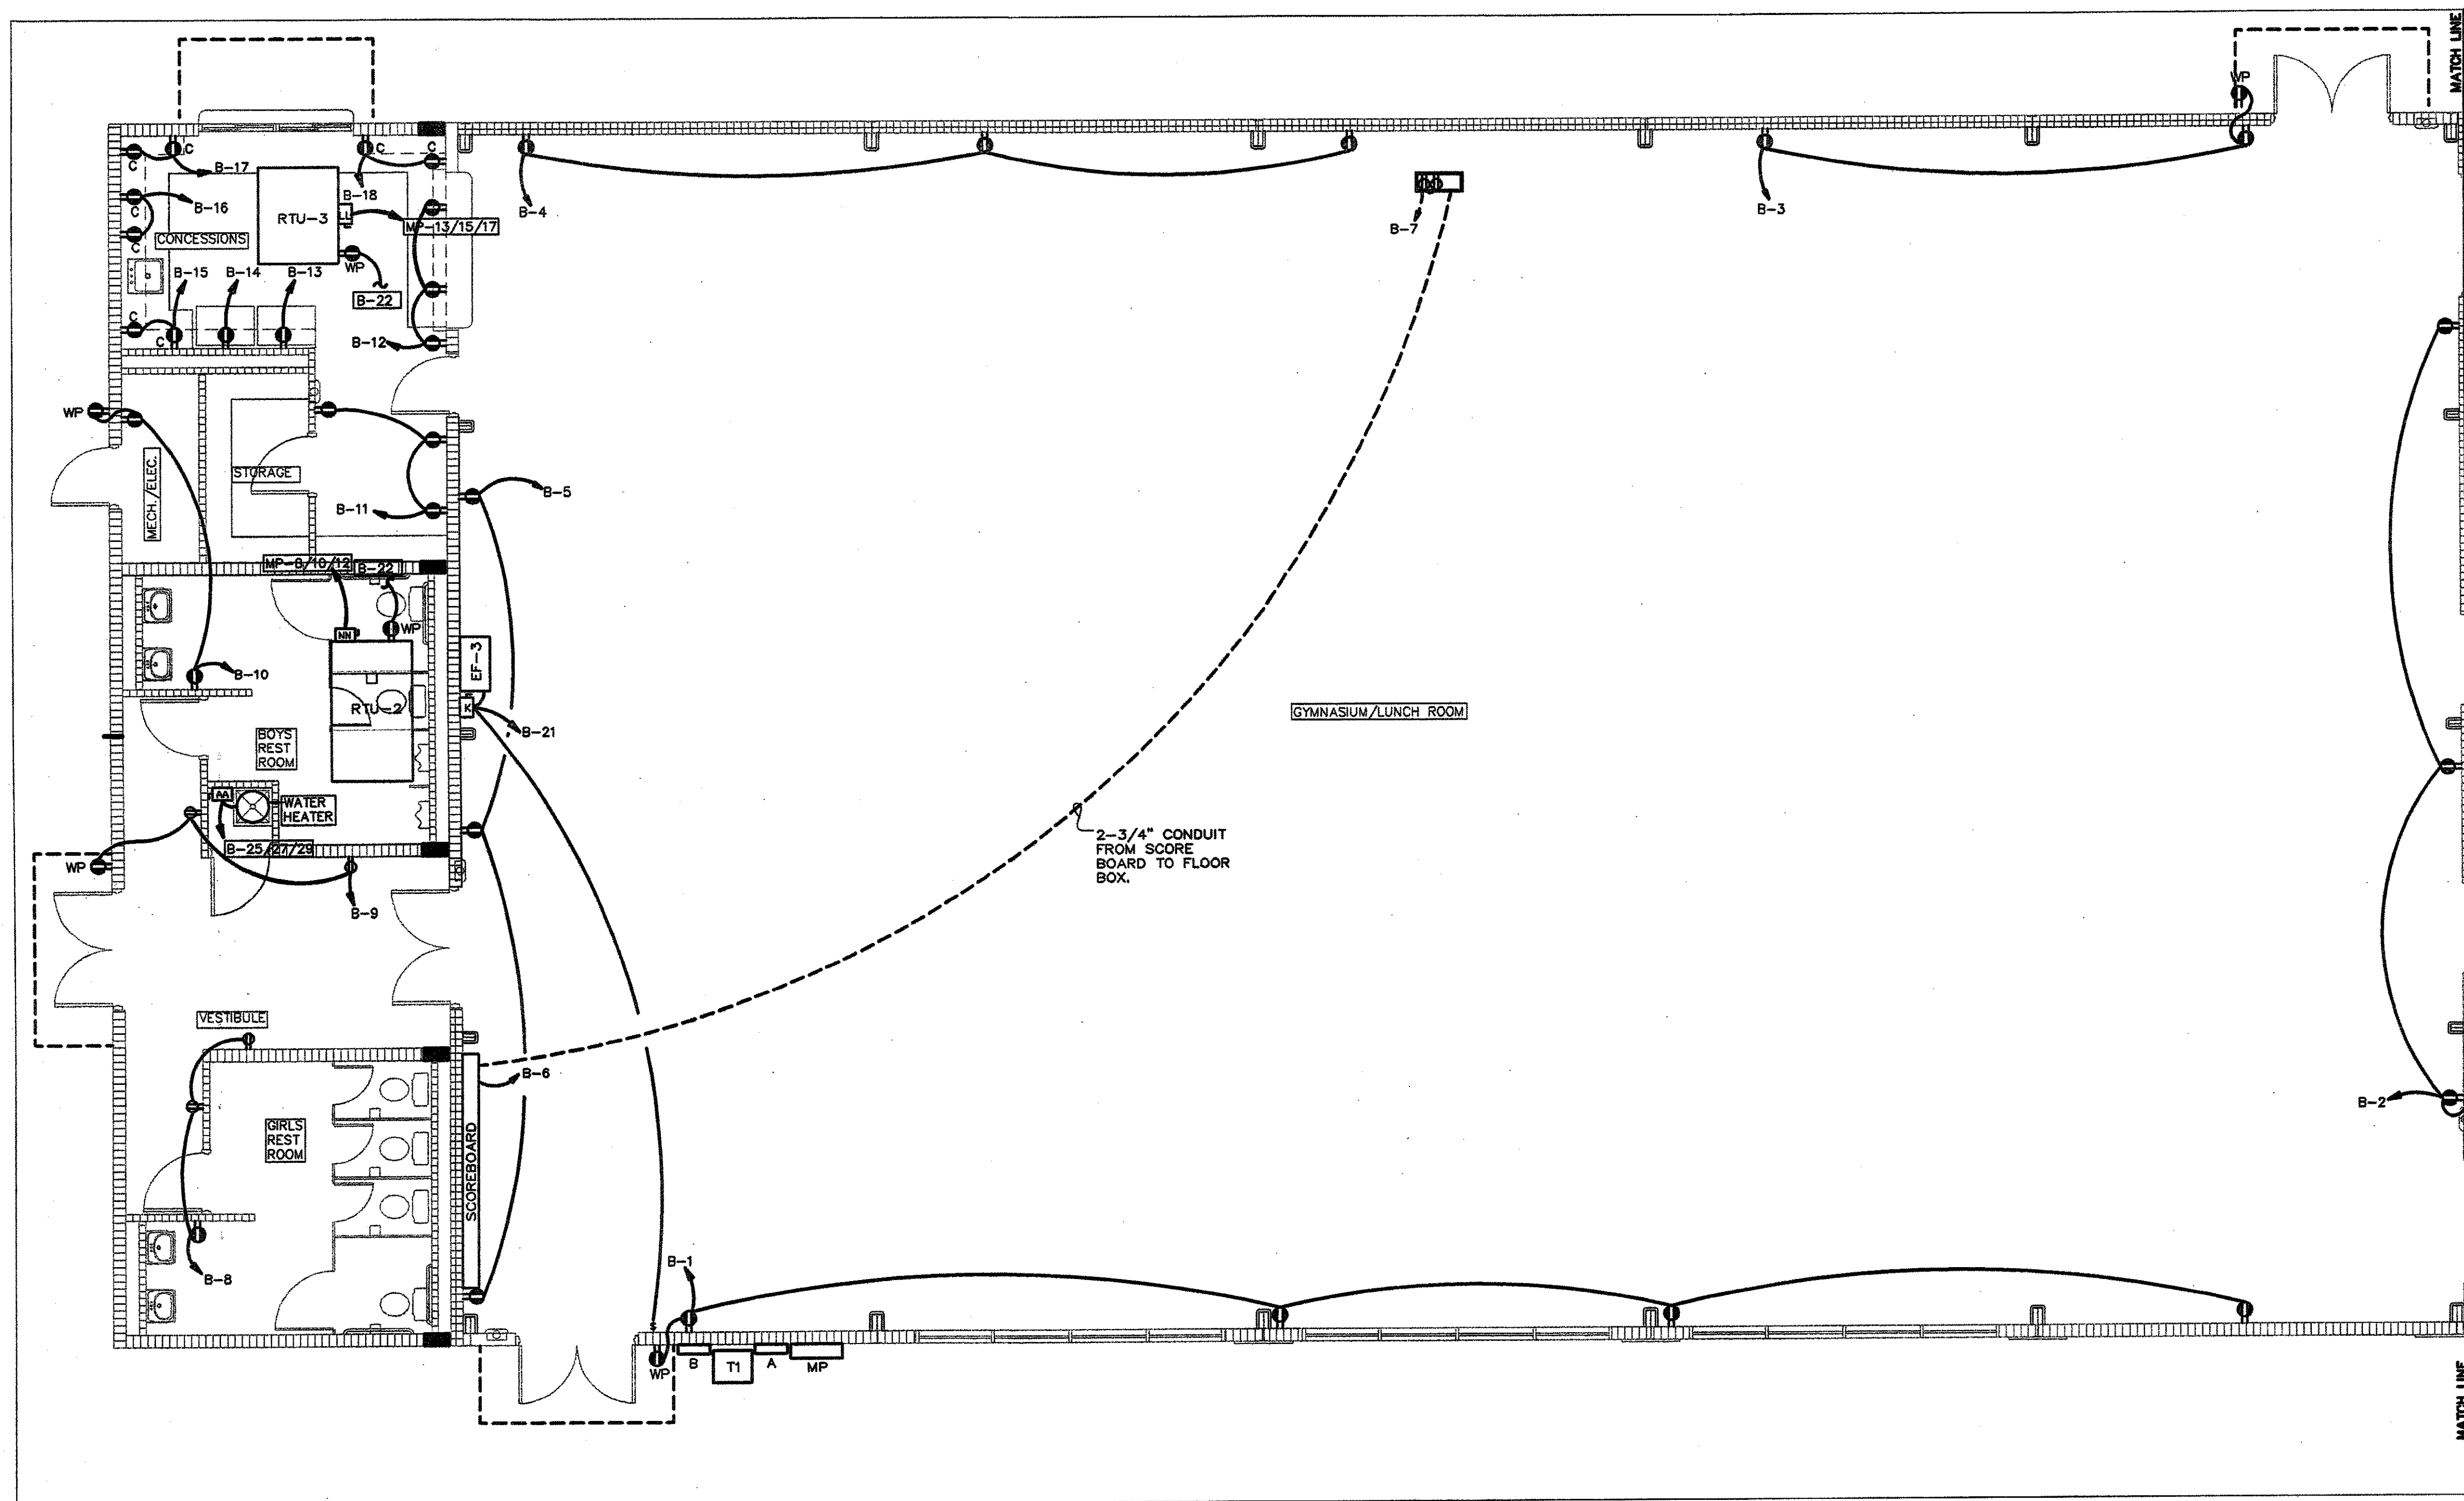

1 ELECTRICAL POWER PLAN
 SCALE: 3/16" = 1'-0"

DRAWN:

SCALE:

MULTI-PURPOSE BUILDING FOR
 NORTHLAKE CHRISTIAN SCHOOL
 70104 WOLVERINE DRIVE
 COVINGTON, LOUISIANA 70433
 FILE: