


 

 
 



 



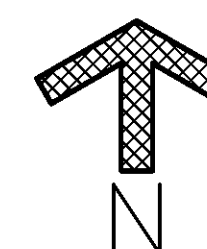


1 ROOF (ATTIC) HATCH WITH WALL MOUNTED LADDER (07720)

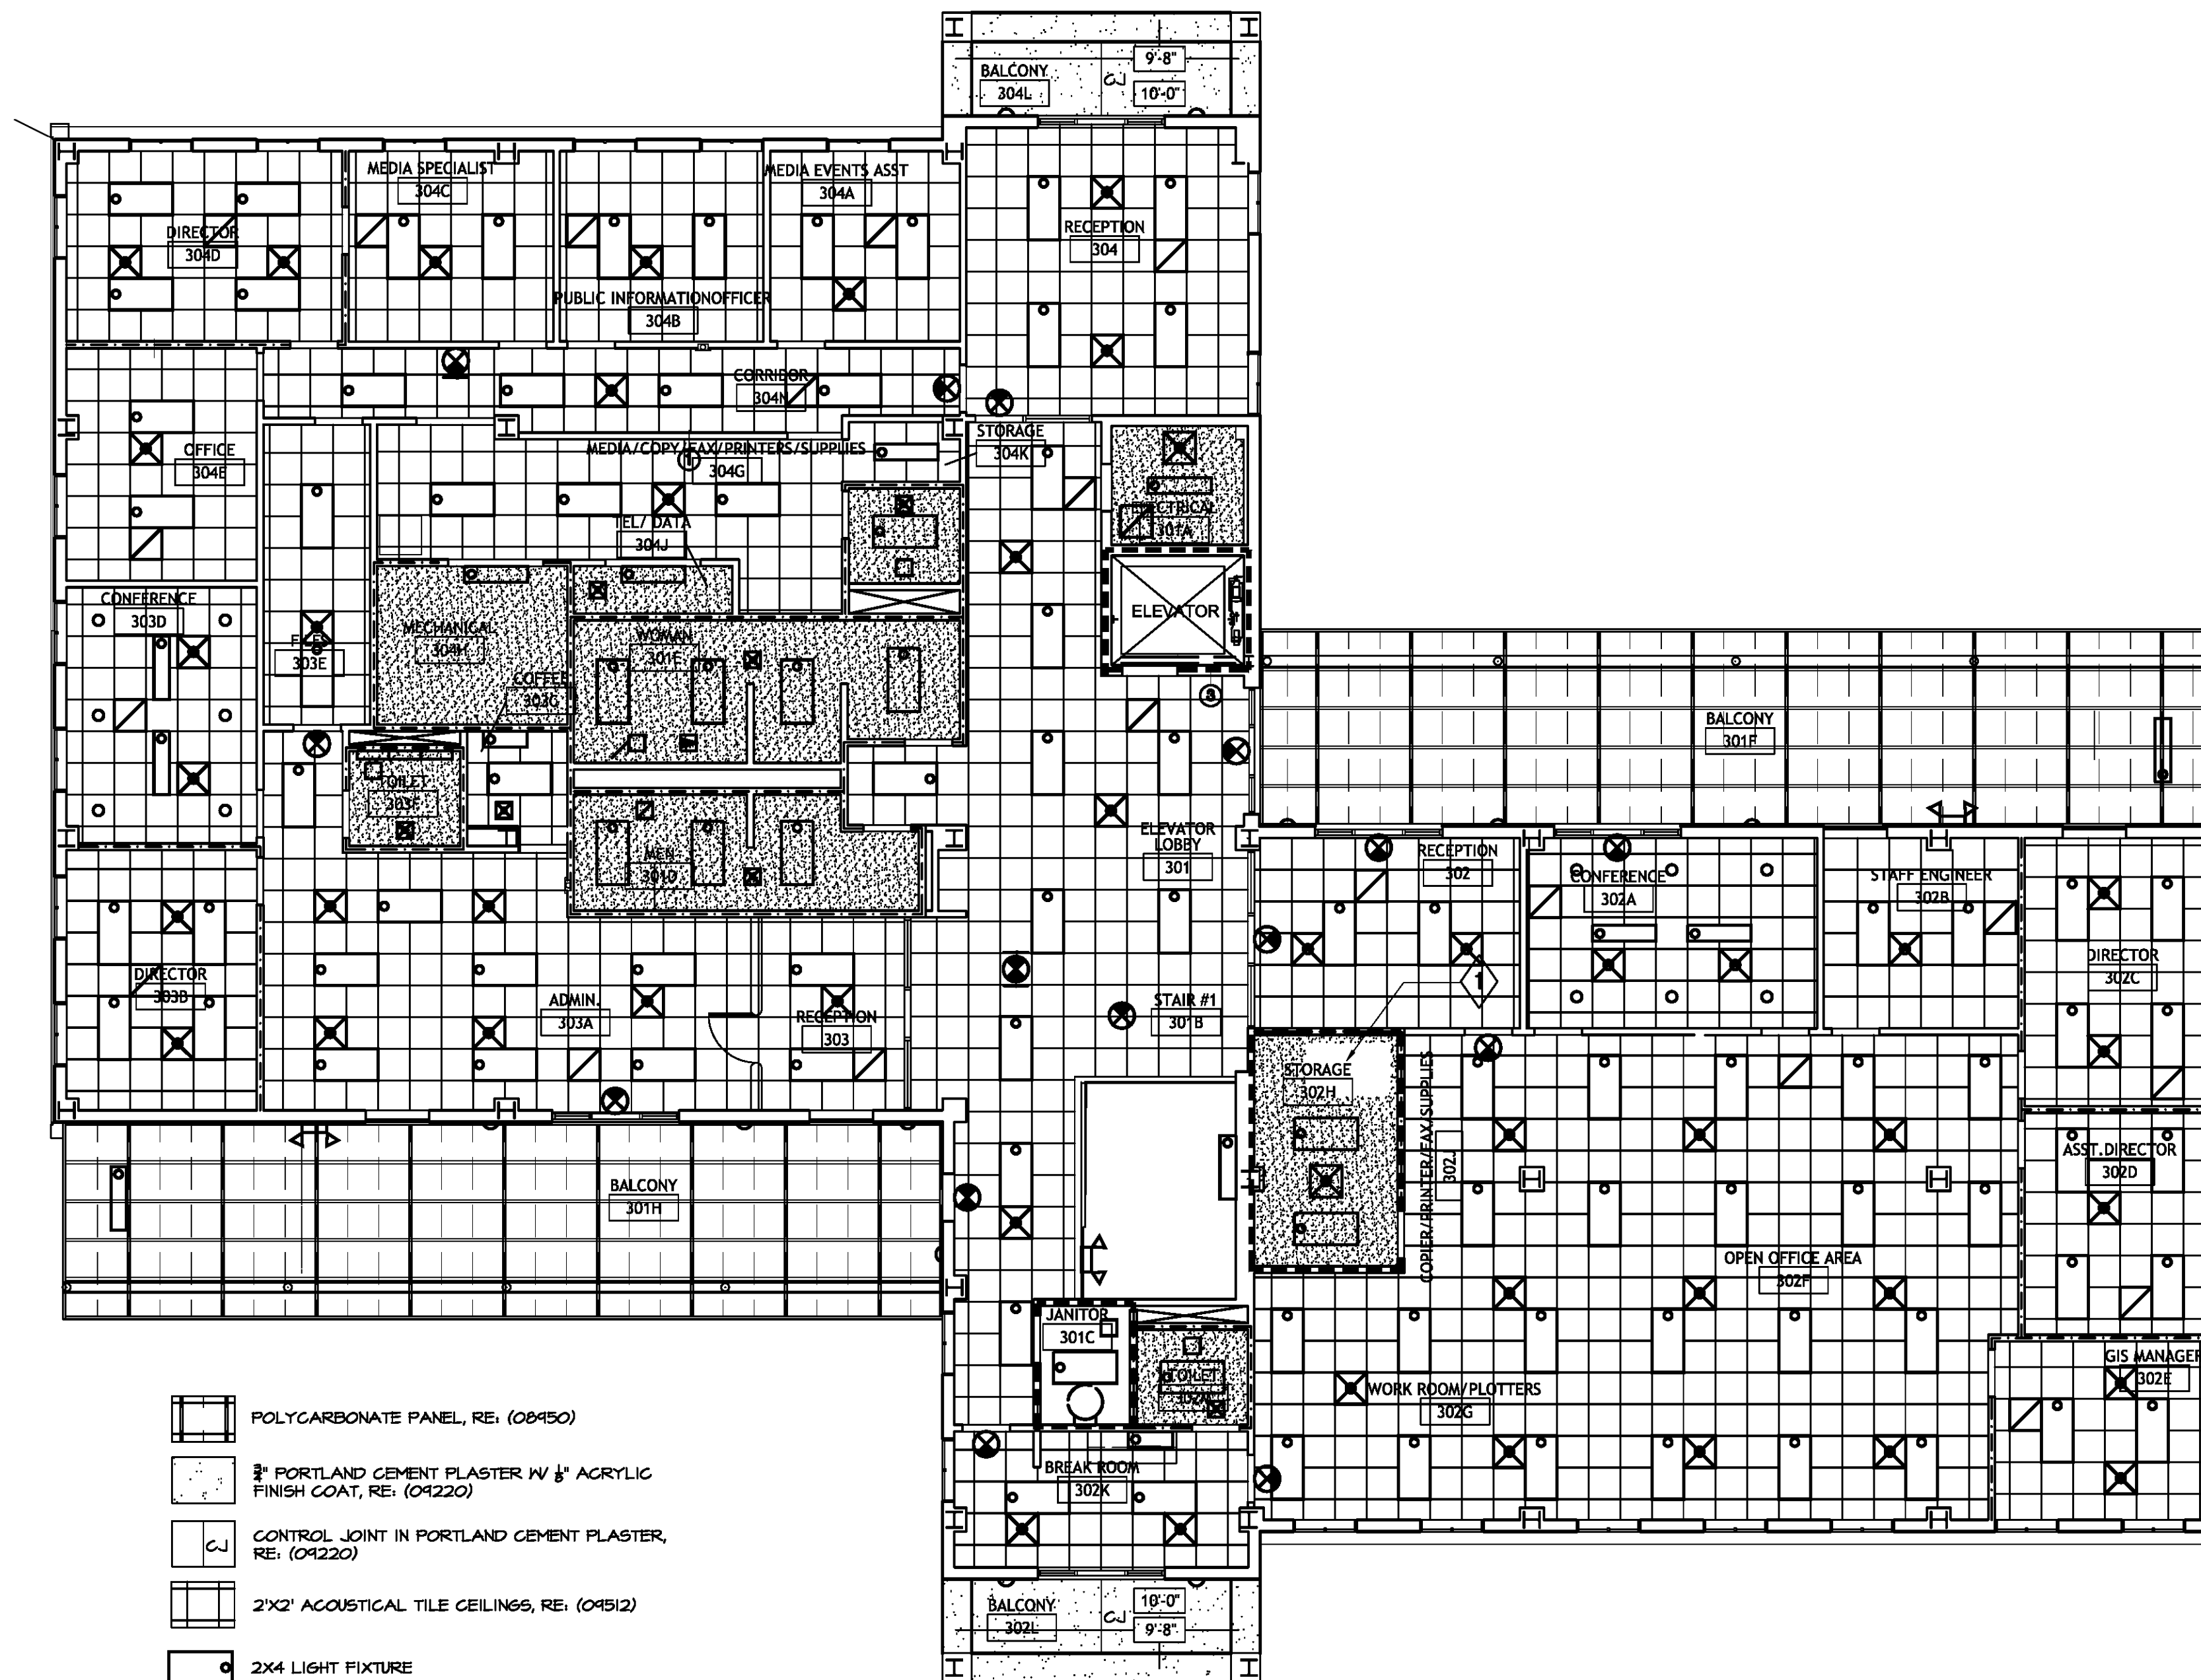

-  POLYCARBONATE PANEL, RE: (08150)
-  3/8" PORTLAND CEMENT PLASTER W/ 1/8" ACRYLIC FINISH COAT, RE: (04220)
-  CONTROL JOINT IN PORTLAND CEMENT PLASTER, RE: (04220)
-  2'X2' ACOUSTICAL TILE CEILING, RE: (04512)
-  2X4 LIGHT FIXTURE
-  WALL OR CEILING MOUNTED LIGHT FIXTURE
-  RECESSED LIGHT FIXTURE
-  DIFFUSER
-  RETURN AIR
-  WALL MOUNTED LIGHT FIXTURE
-  EXIT SIGN
-  EMERGENCY LIGHT FIXTURE
-  WATER HEATER SUSPENDED FROM METAL DECKING



1. THIRD FLOOR REFLECTED CEILING PLAN
SCALE: 1/8" = 1'-0"



PROJECT DESIGN GROUP, LLC
300 LAFAYETTE STREET, SUITE 200
NEW ORLEANS, LOUISIANA 70130
(504) 523-6472 FAX (504) 529-1181




REK ARCHITECTS, LLC
21489 KOOP DRIVE, SUITE 5
MANDEVILLE, LOUISIANA 70471
(985) 875-7534 FAX (985) 875-7837

revisions		
no.	revision	date

SLIDELL MUNICIPAL CENTER
BUILDING 2
SLIDELL, LA

THIRD FLOOR REFLECTED CEILING PLAN

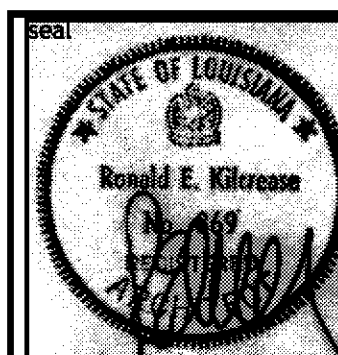

file name	drawing number
project number 51093.02	A8.2
date 9-5-09	
phase CD	