


MEYER ENGINEERS, LTD.
 ENGINEER & ARCHITECT

AREA 'B' CEILING PLAN
 VAL RISS PARK
 MULTI-PURPOSE BUILDING
 ST. BERNARD PARISH, OWNER

sheet no.
A27
 of ___ sheets

CEILING LEGEND

- 2' x 2' SUSPENDED ACOUSTICAL TILE CEILING
- 5/8" GYPSUM BOARD CEILING AND SUSPENSION SYSTEM
- PRE-FINISHED METAL SOFFIT PANELS AND SUSPENSION SYSTEM
- WALL MOUNTED LIGHT FIXTURE; RE: ELECTRICAL LIGHTING PLAN
- 2x4 LAY-IN LIGHT FIXTURE; RE: ELECTRICAL LIGHTING PLAN
- SUSPENDED LIGHT FIXTURE; RE: ELECTRICAL LIGHTING PLAN
- SURFACE MOUNTED LIGHT FIXTURE; RE: ELECTRICAL LIGHTING PLAN
- HI-BAY SUSPENDED LIGHT FIXTURE; RE: ELECTRICAL LIGHTING PLAN
- HI-BAY SUSPENDED LIGHT FIXTURE; RE: ELECTRICAL LIGHTING PLAN
- WALL MOUNTED LIGHT FIXTURE; RE: ELECTRICAL LIGHTING PLAN
- ILLUMINATED EXIT SIGN; RE: ELECTRICAL LIGHTING PLAN
- SIDE WALL SUPPLY AIR DIFFUSER; RE: HVAC PLAN
- EXHAUST / RETURN GRILL, TYP.; RE: HVAC PLAN
- SUPPLY DIFFUSER, TYP.; RE: HVAC PLAN
- SUSPENDED FIXTURE; RE: ELECTRICAL LIGHTING PLAN

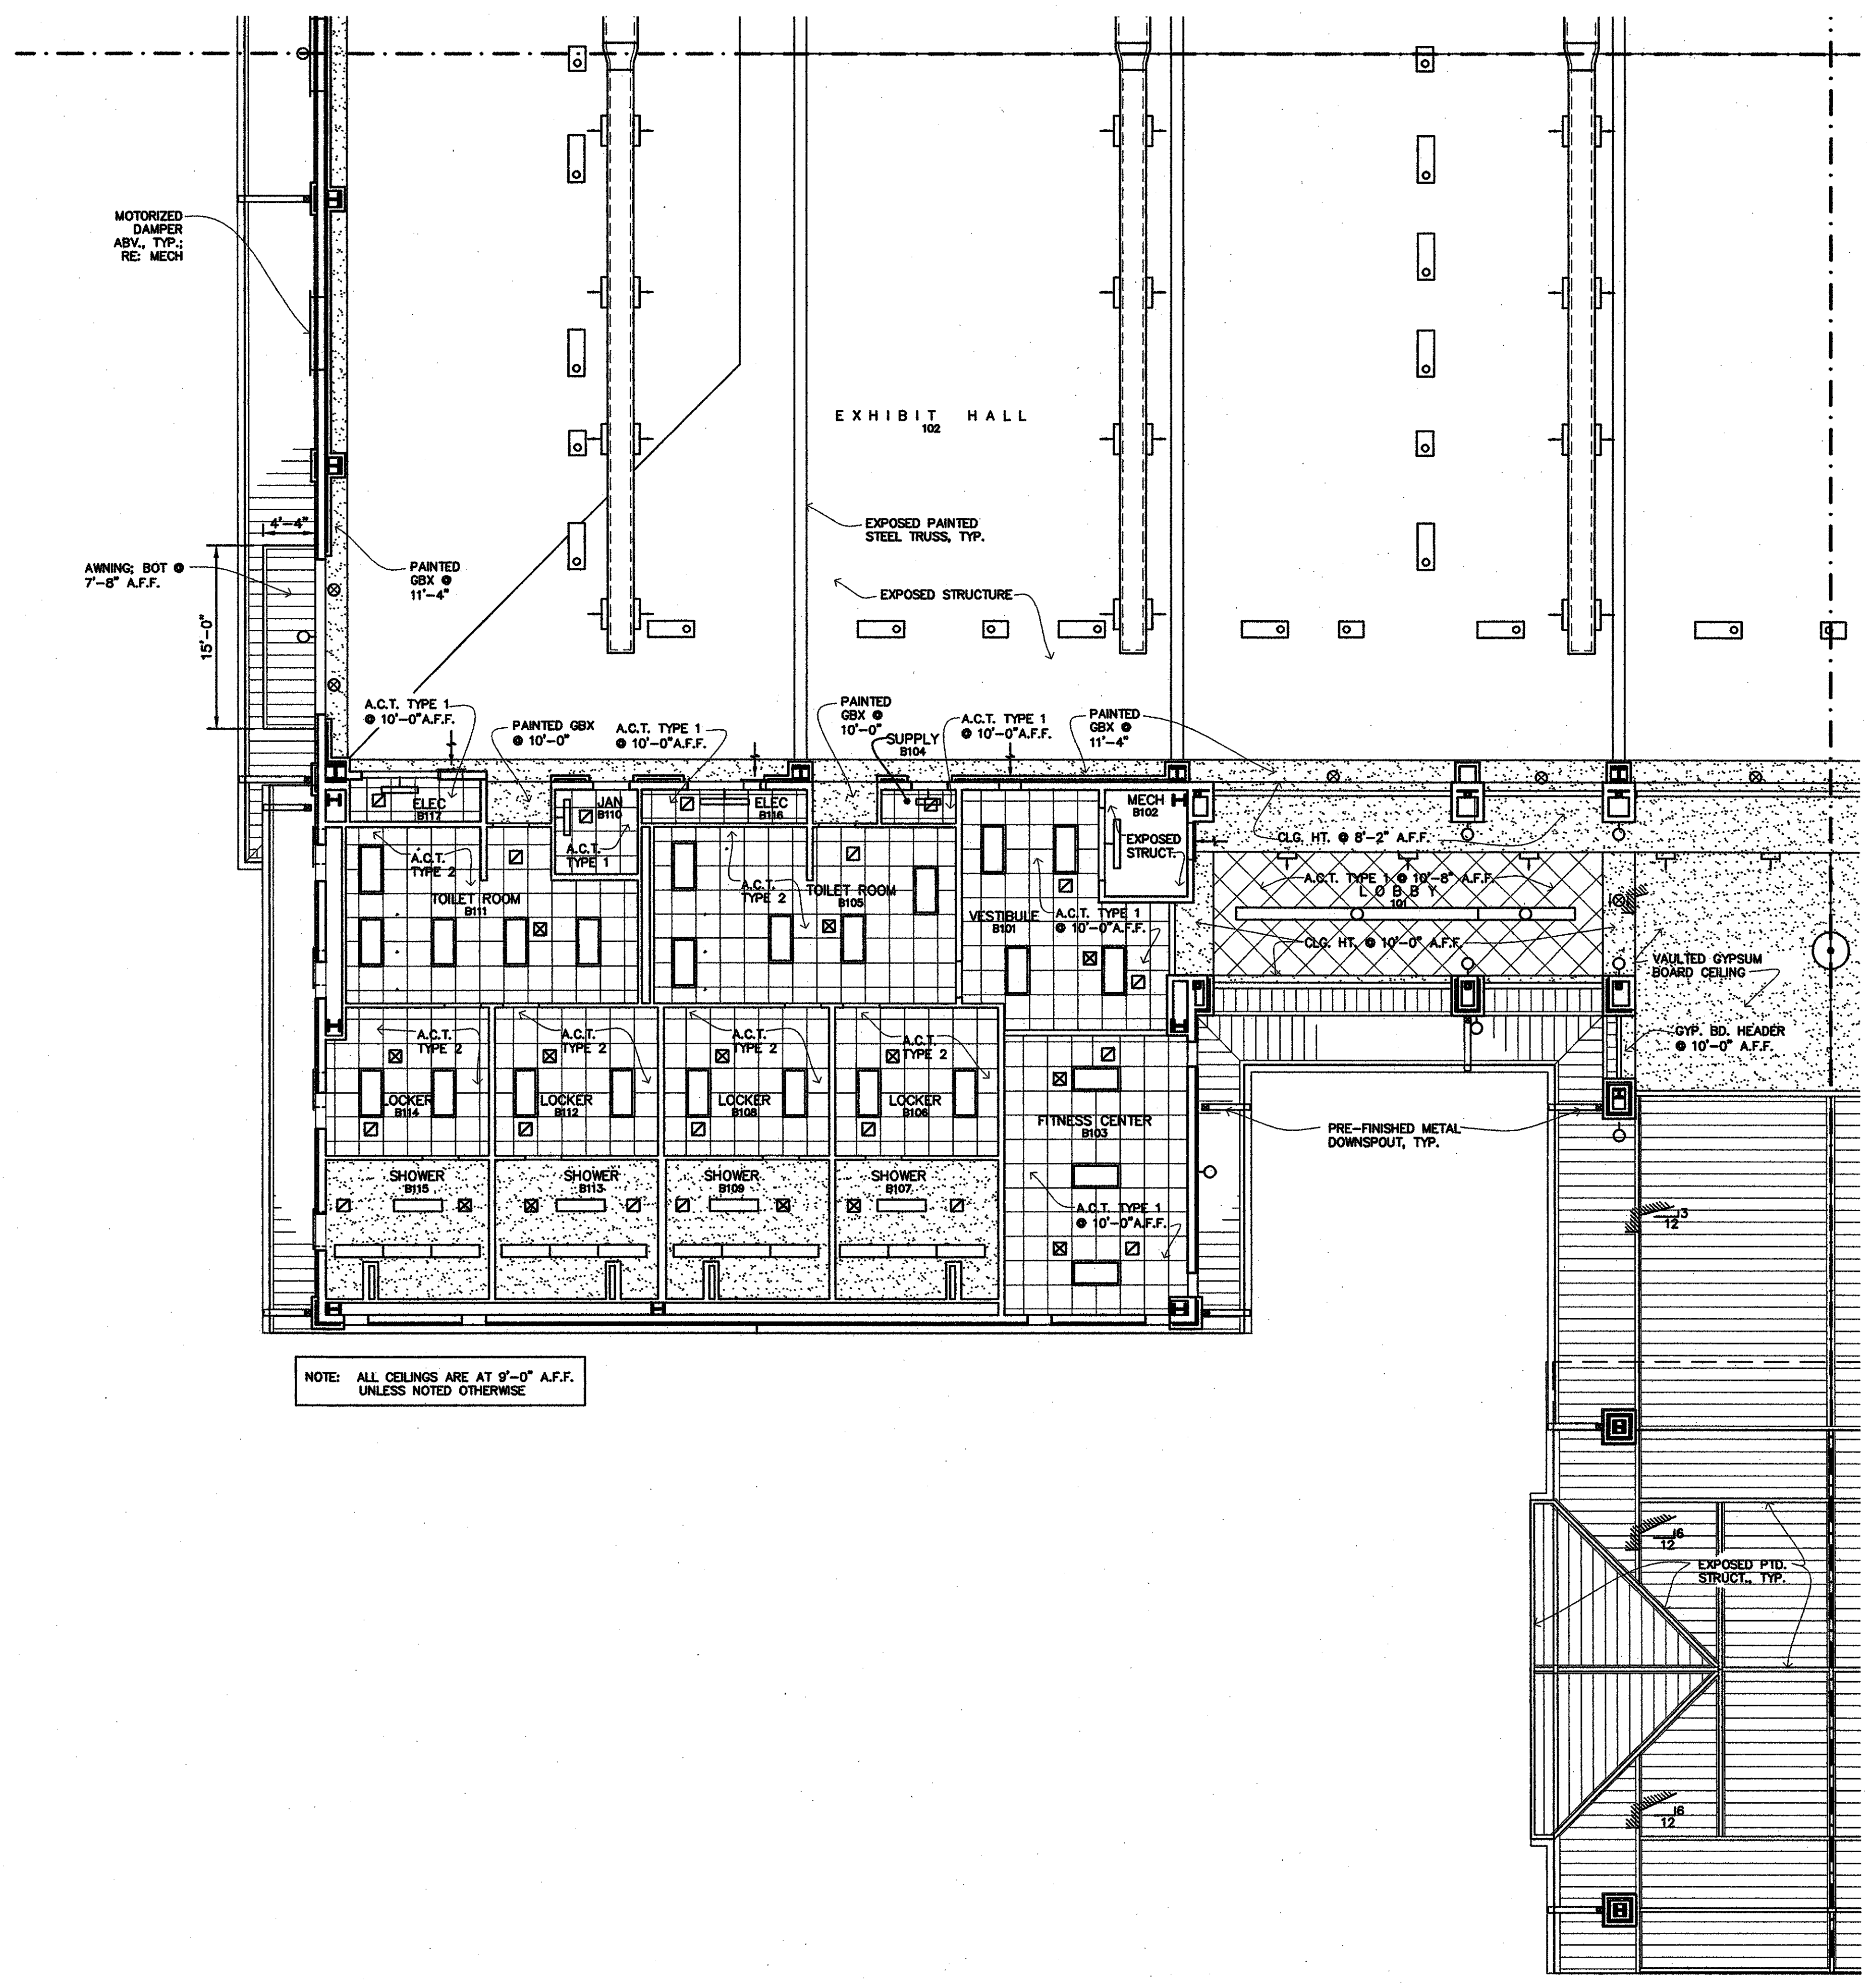

NOTE: ALL CEILINGS ARE AT 9'-0" A.F.F. UNLESS NOTED OTHERWISE

1 AREA 'B' CEILING PLAN
 A2.7 | A2.7 1/8" = 1'-0"